




1 LOCATION MAP 7
A-02 SCALE 100 M

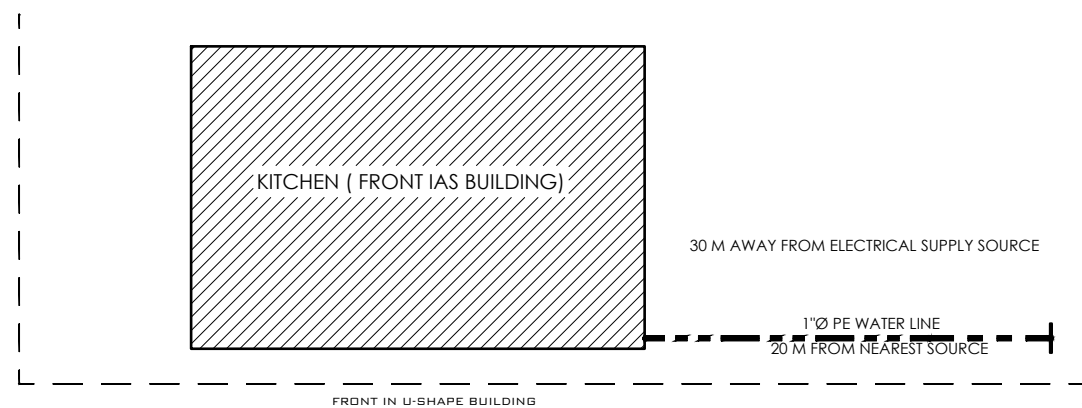


2 LOCATION MAP 8
A-02 SCALE 100 M

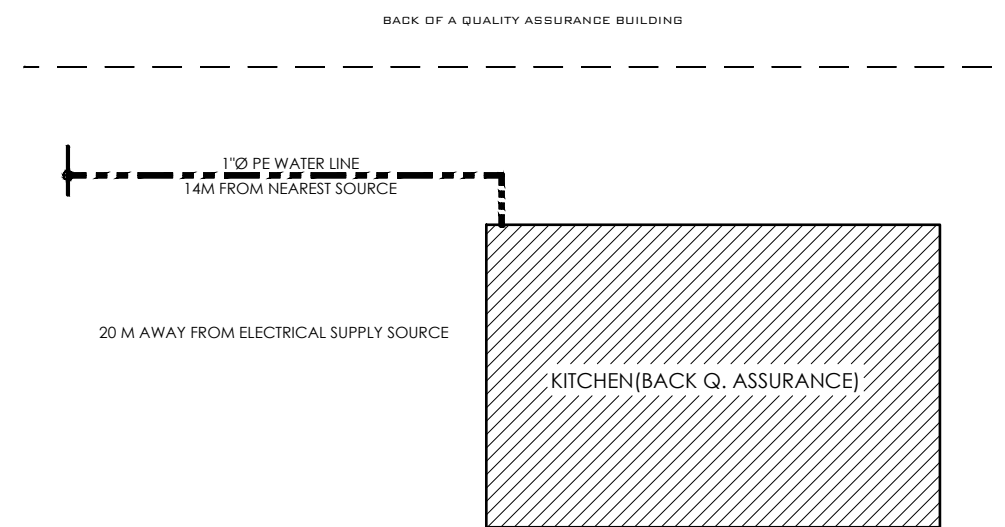

3 LOCATION MAP 9
A-02 SCALE 100 M

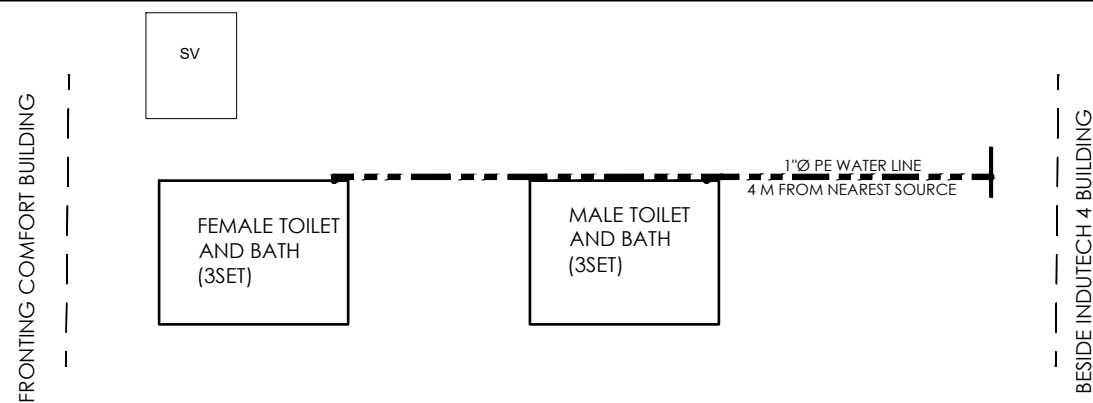

4 LOCATION MAP 10
A-02 SCALE 100 M

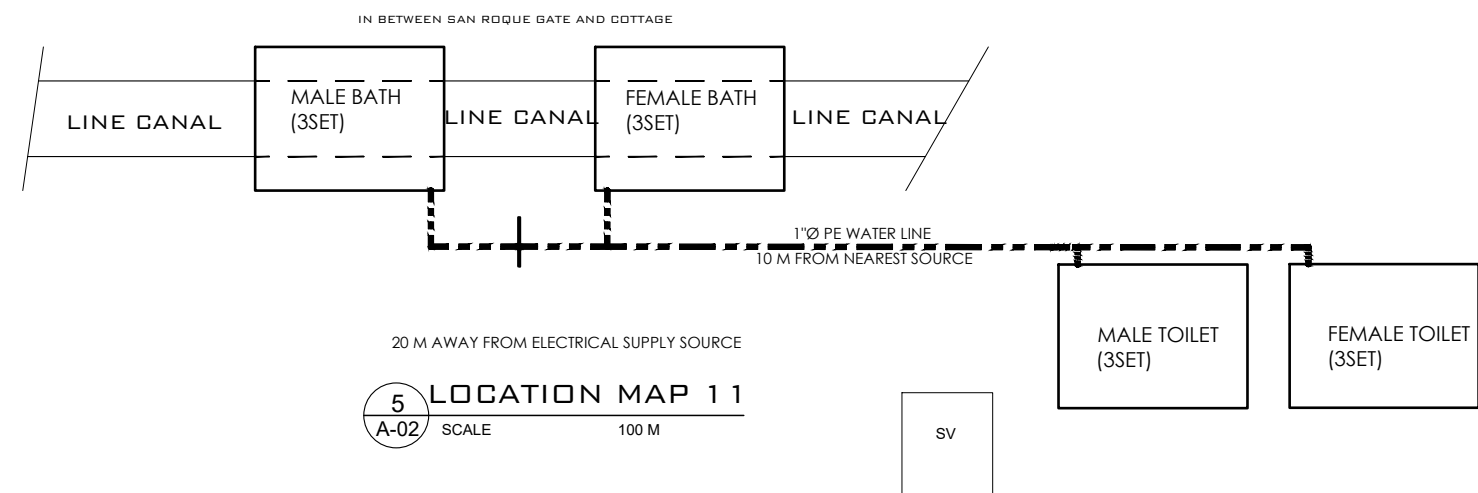

5 LOCATION MAP 11
A-02 SCALE 100 M



SOUTHERN LEYTE STATE UNIVERSITY
SOGOD, SOUTHERN LEYTE
www.slsuonline.edu.ph
email: ssumaincampus@gmail.com
telefax: (053) 577-3229

PREPARED BY :

KURT ALEX ROMERO
DRAFTSMAN-GJT
MARLOU CASTIGON
DRAFTSMAN-GJT
MELI ANN B. TAGUD
DRAFTSMAN-GJT

REVIEWED BY:

ELDIE L. MACUTO
DRAFTSMAN-GJT
JASON P. JAYAGAN
DRAFTSMAN-GJT
ENGR. RYAN A. MACUTO
CAMPUS ENGINEER DESIGNATE

PROJECT :

MAKESHIFT TOILET, BATHROOM AND KITCHEN FOR SCUAA DELEGATES

OWNER :

SOUTHERN LEYTE STATE UNIVERSITY

APPROVED AS PER PLAN :

PROSE IVY G. YEPES, Ed. D.
UNIVERSITY PRESIDENT

SHEET CONTENT

AS SHOWN

SHEET NO.


A-02

LOCATION: SLSU-MAIN CAMPUS, SAN ROQUE, SOGOD SOUTHERN LEYTE


ADDRESS: SOGOD, SOUTHERN LEYTE

CHECKED : _____ DRAWN : _____ SCALE AS SHOWN @ 20x30
APPROVED : _____ DATE : _____


PROJ. NO.

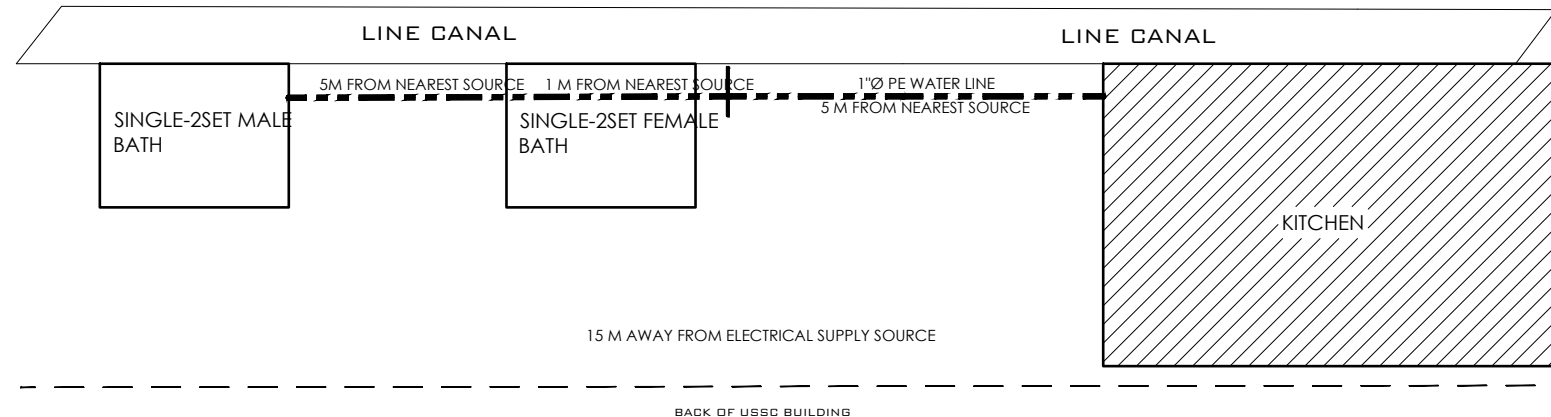


1 LOCATION MAP 11
A-03 SCALE 100 M

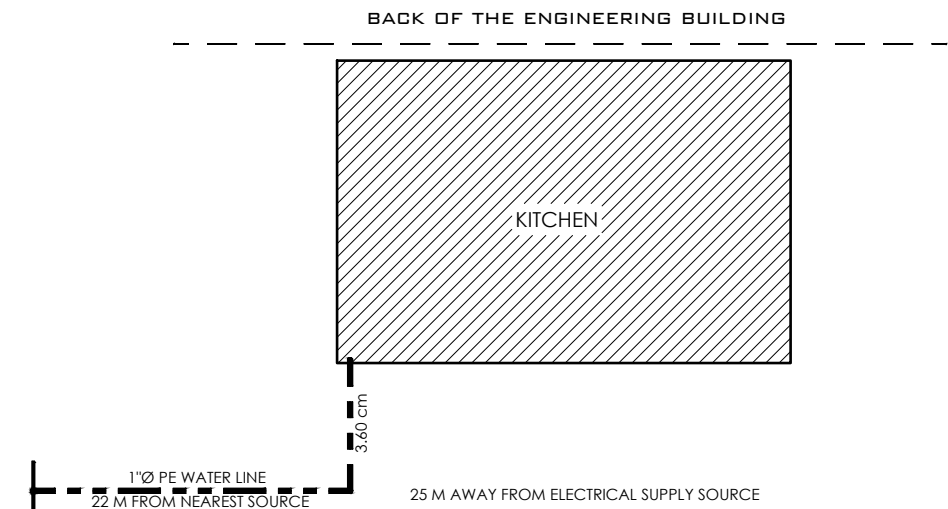


4 LOCATION MAP 12
A-03 SCALE 100 M

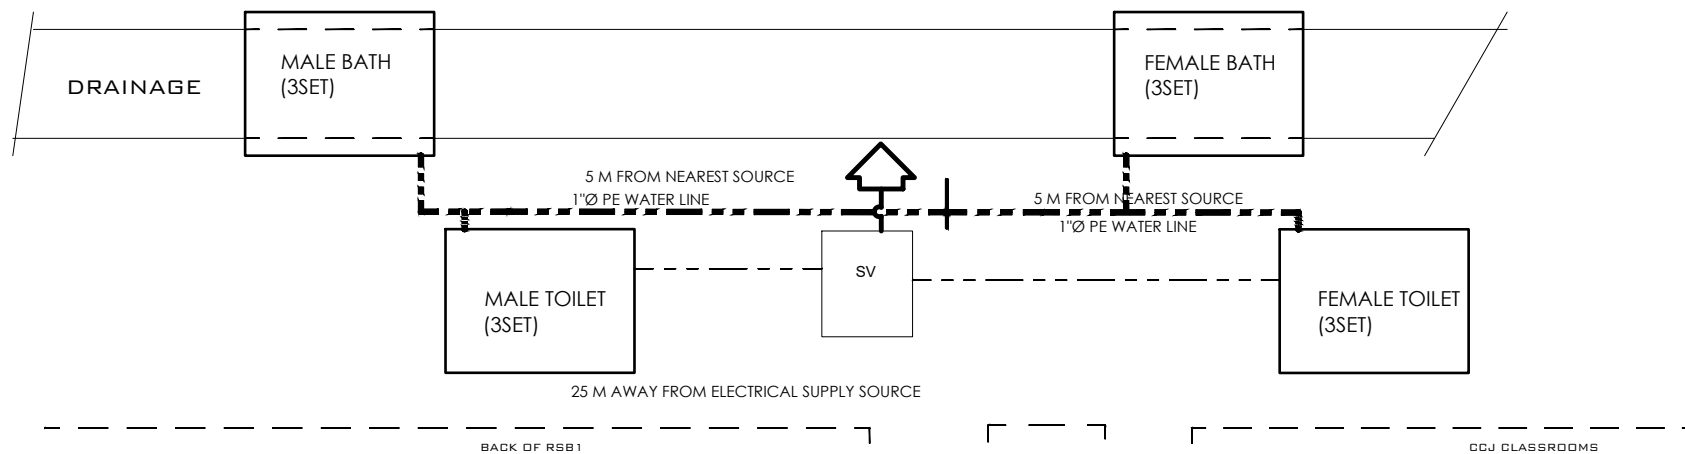


2 LOCATION MAP 13
A-03 SCALE 100 M

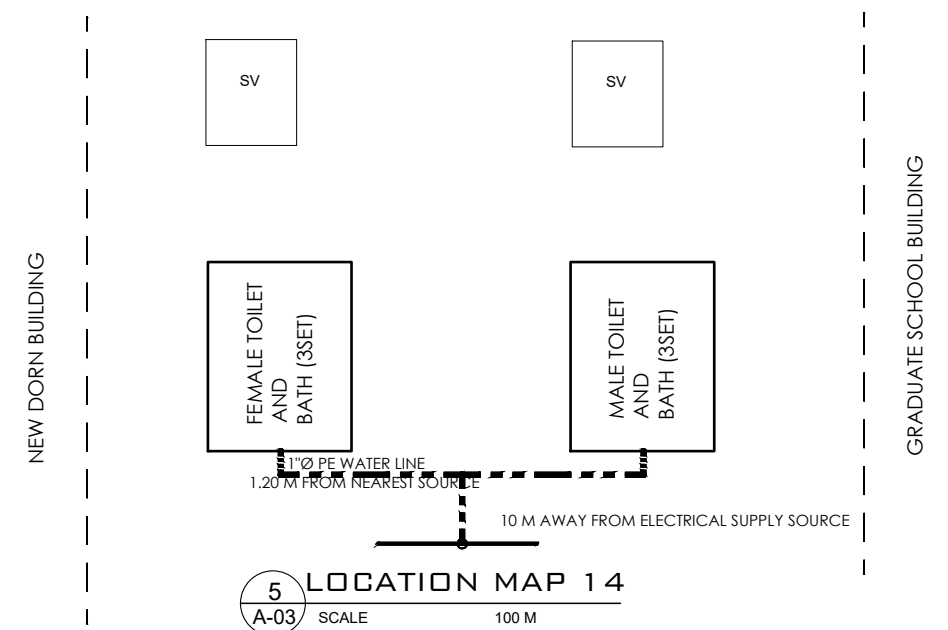


5 LOCATION MAP 14
A-03 SCALE 100 M

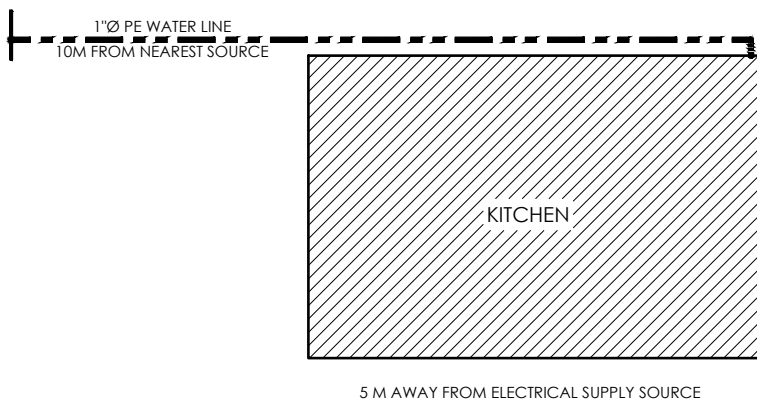

3 LOCATION MAP 15
A-03 SCALE 100 M

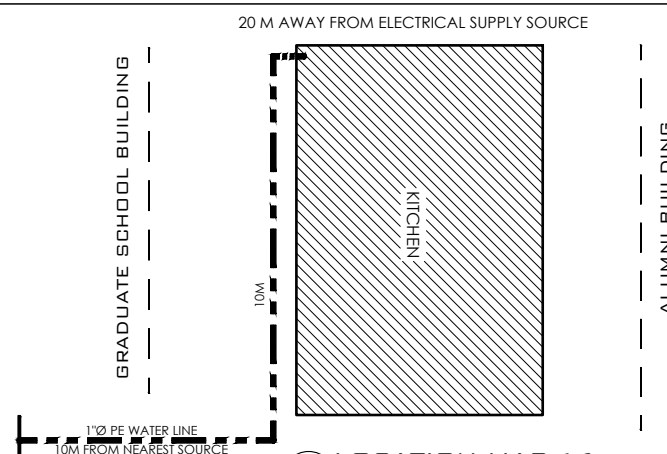

6 LOCATION MAP 16
A-03 SCALE 100 M

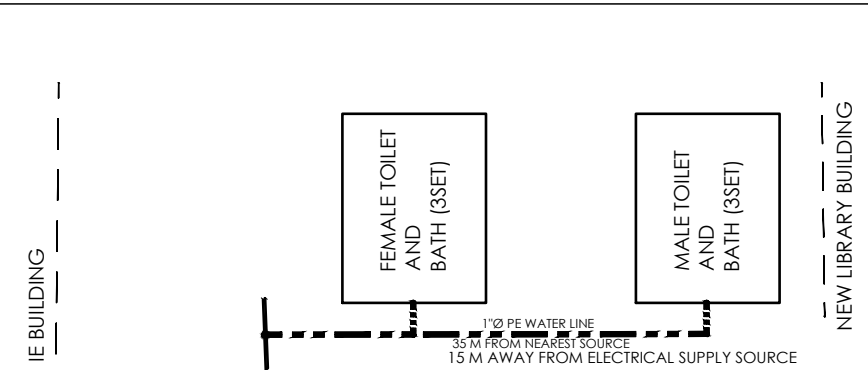

7 LOCATION MAP 17
A-03 SCALE 100 M



SOUTHERN LEYTE STATE UNIVERSITY
SOGOD, SOUTHERN LEYTE
www.slsuonline.edu.ph
email: ssumaincampus@gmail.com
telefax: (053) 577-3229

PREPARED BY:
KURT ALEX ROMERO, DRAFTSMAN-OJT
ELDIE L. MACUTO, DRAFTSMAN-OJT
MARLOU CASTIGON, DRAFTSMAN-OJT
JASON P. JAYAGAN, DRAFTSMAN-OJT
MELI ANN B. TAGUD, DRAFTSMAN-OJT

REVIEWED BY:
ENGR. RYAN A. MACUTO
CAMPUS ENGINEER DESIGNATE


PROJECT:
MAKESHIFT TOILET, BATHROOM AND KITCHEN FOR SCUAA DELEGATES
LOCATION: SLSU-MAIN CAMPUS, SAN ROQUE, SOGOD SOUTHERN LEYTE

OWNER:
SOUTHERN LEYTE STATE UNIVERSITY
ADDRESS: SOGOD, SOUTHERN LEYTE


APPROVED AS PER PLAN:
PROSE IVY G. YEPES, Ed. D.
UNIVERSITY PRESIDENT

SHEET CONTENT
AS SHOWN
CHECKED: _____ DRAWN: _____ SCALE: AS SHOWN @ 20x30
APPROVED: _____ DATE: _____ PROJ. NO. _____


SHEET NO. A-03

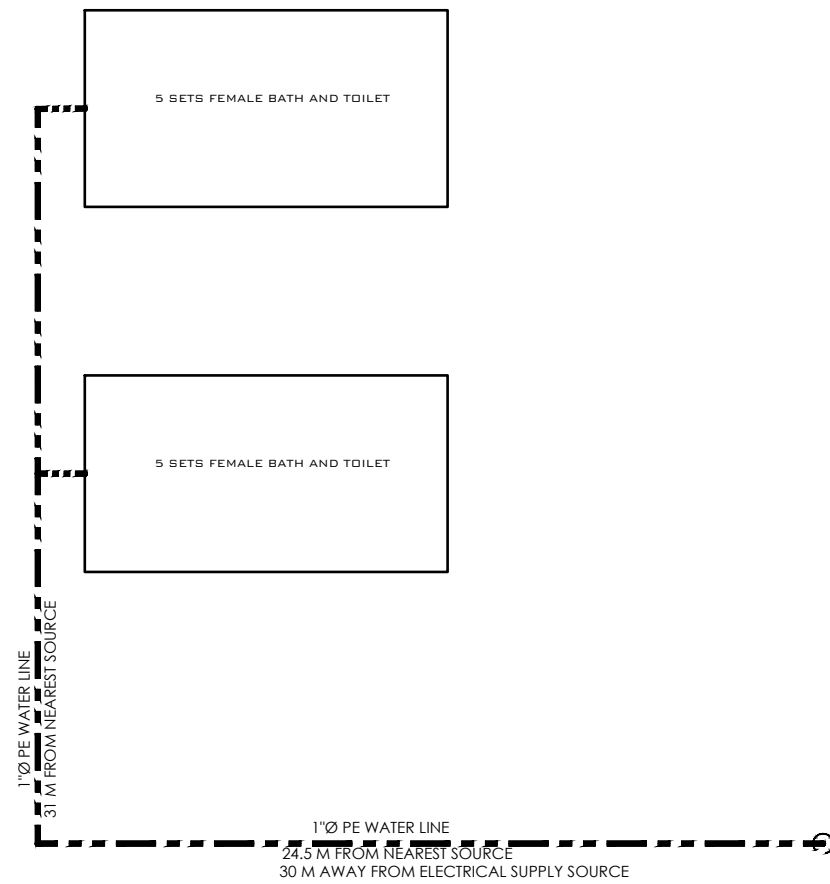


1 LOCATION MAP 17
A-04 SCALE 100 M

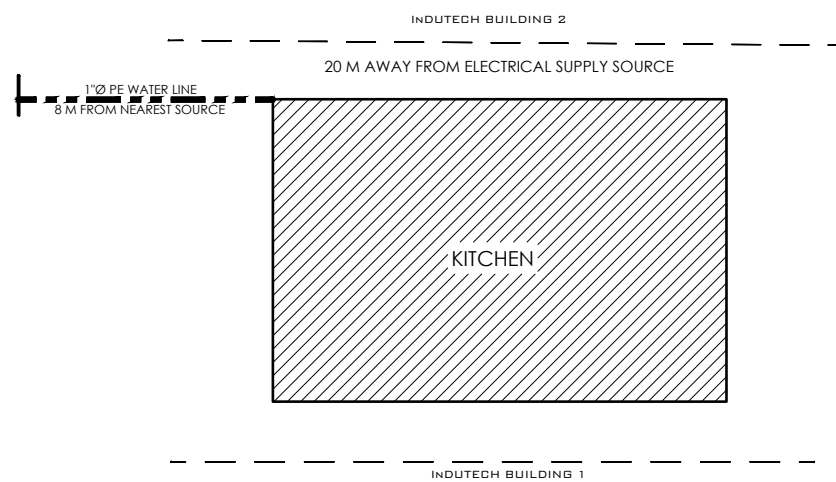

2 LOCATION MAP 18
A-04 SCALE 100 M

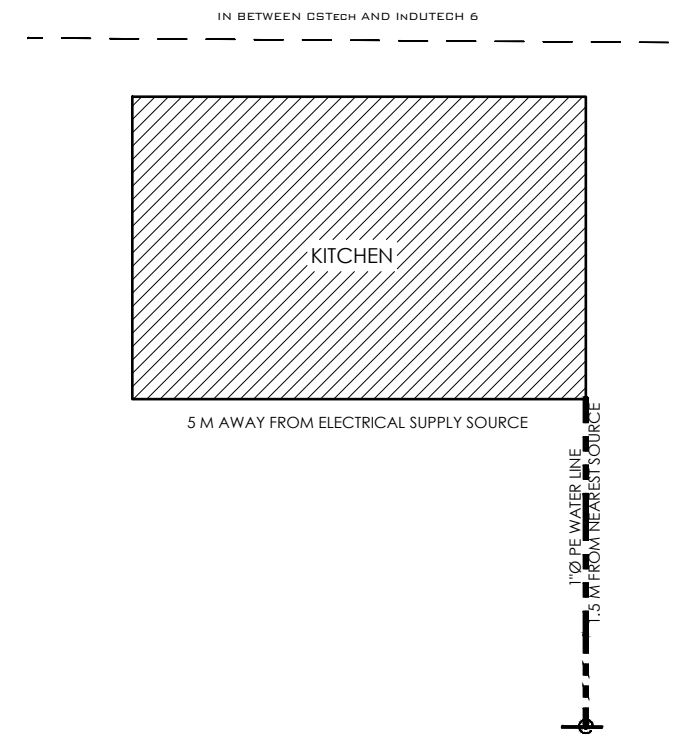

3 LOCATION MAP 18
A-04 SCALE 100 M

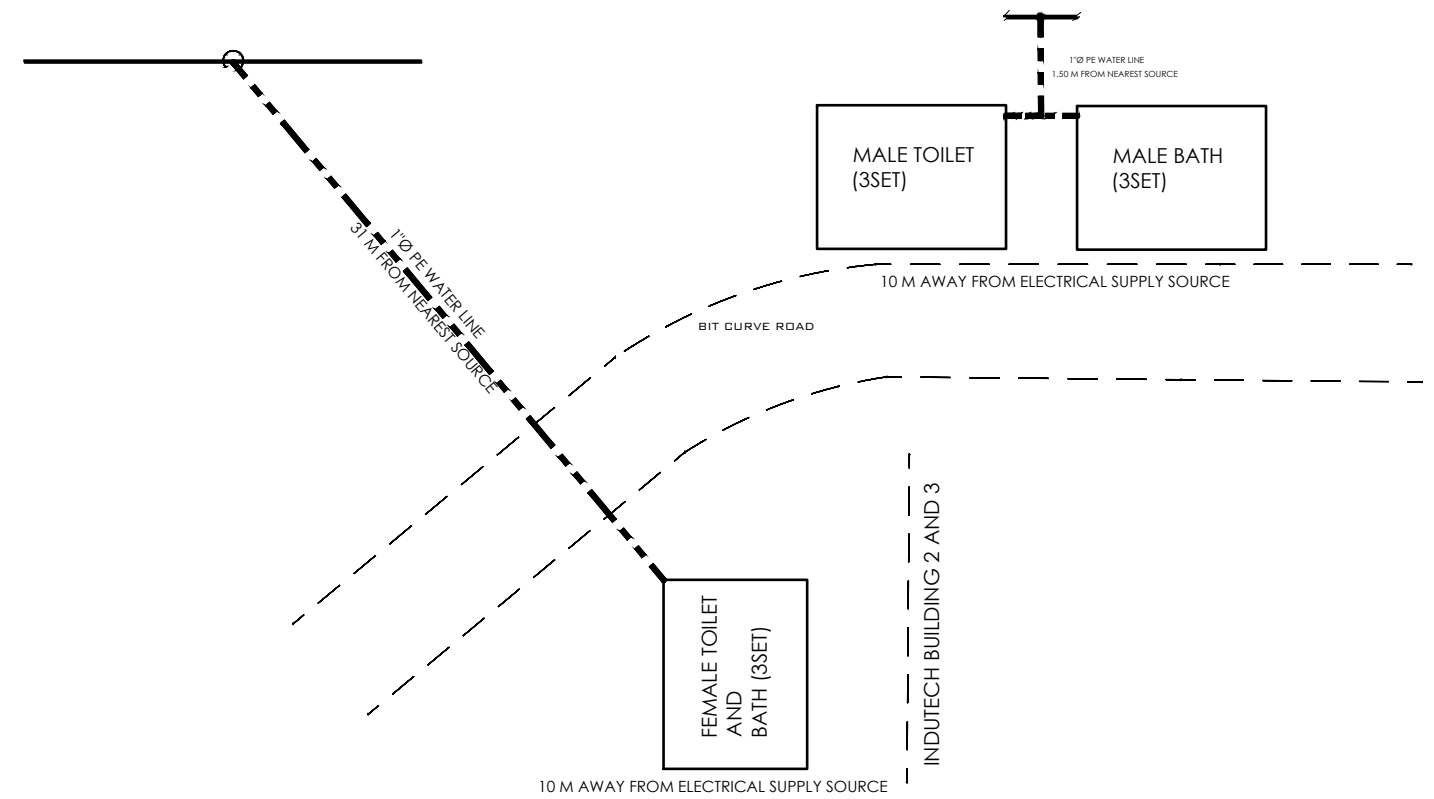

4 LOCATION MAP 17
A-04 SCALE 100 M



SOUTHERN LEYTE STATE UNIVERSITY
SOGOD, SOUTHERN LEYTE
www.slsuonline.edu.ph
email: ssumaincampus@gmail.com
telefax: (053) 577-3229

PREPARED BY:
KURT ALEX ROMERO (DRAFTSMAN-OJT)
ELDIE L. MACUTO (DRAFTSMAN-OJT)
MARLOU CASTIGON (DRAFTSMAN-OJT)
JASON P. JAYAGAN (DRAFTSMAN-OJT)
MELI ANN B. TAGUD (DRAFTSMAN-OJT)


REVIEWED BY:
ENGR. RYAN A. MACUTO
CAMPUS ENGINEER DESIGNATE

PROJECT:
MAKESHIFT TOILET, BATHROOM AND KITCHEN FOR SCUAA DELEGATES
LOCATION: SLSU-MAIN CAMPUS, SAN ROQUE, SOGOD SOUTHERN LEYTE


OWNER:
SOUTHERN LEYTE STATE UNIVERSITY
ADDRESS: SOGOD, SOUTHERN LEYTE

APPROVED AS PER PLAN:
PROSE IVY G. YEPES, Ed. D.
UNIVERSITY PRESIDENT


SHEET CONTENT
AS SHOWN
CHECKED : _____ DRAWN : _____ SCALE AS SHOWN @ 20x30
APPROVED : _____ DATE : _____
SHEET NO. A-04
PROJ. NO.

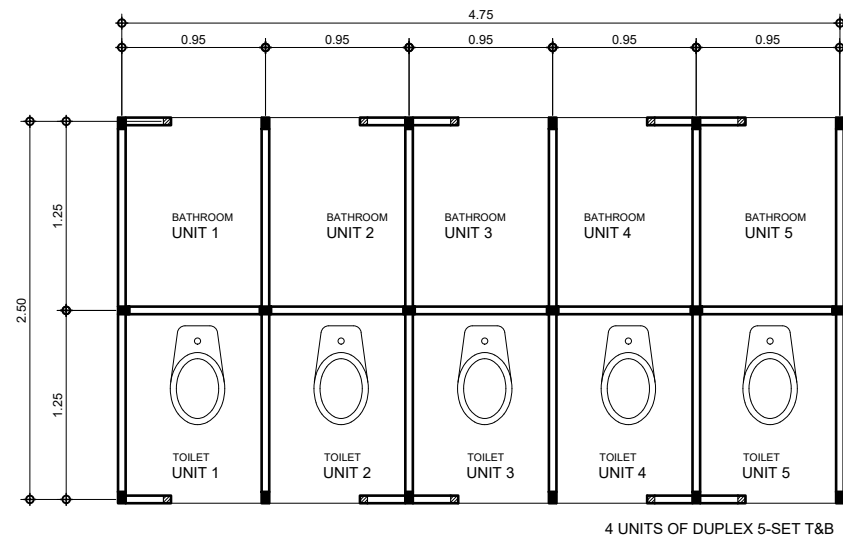


1
A-05 SCALE 1:100 M
DUPLEX 5-SET T&B FLOOR PLAN

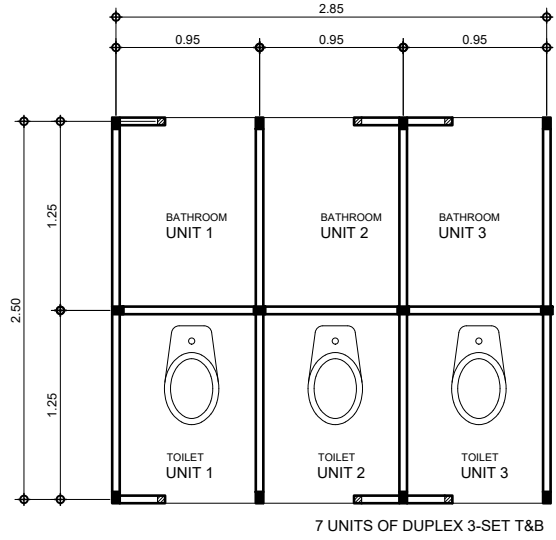


4
A-05 SCALE 1:100 M
DUPLEX 3-SET T&B FLOOR PLAN

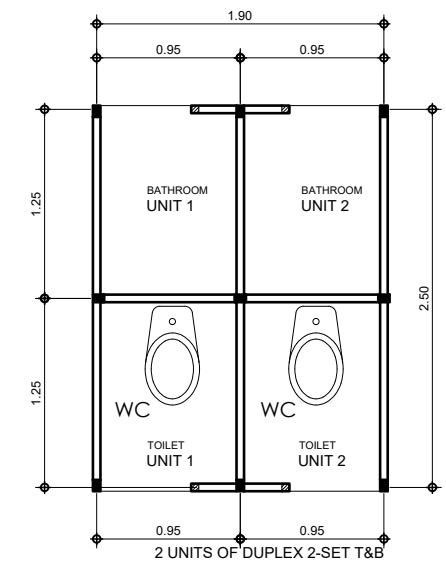


7
A-05 SCALE 1:100 M
DUPLEX 2-SET T&B FLOOR PLAN

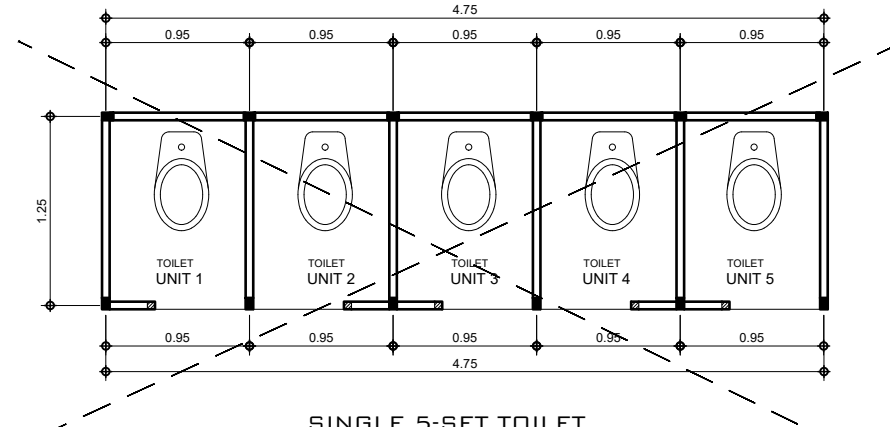


2
A-05 SCALE 1:100 M
SINGLE 5-SET TOILET FLOOR PLAN

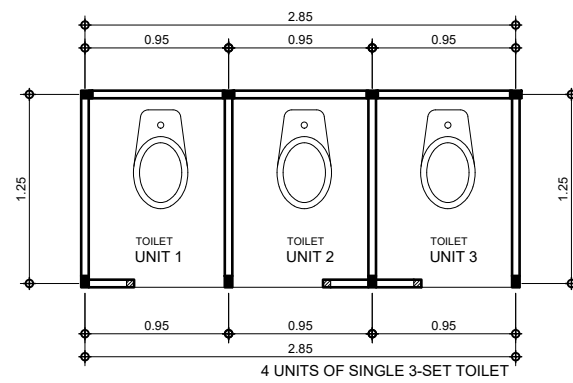


5
A-05 SCALE 1:100 M
SINGLE 3-SET TOILET FLOOR PLAN

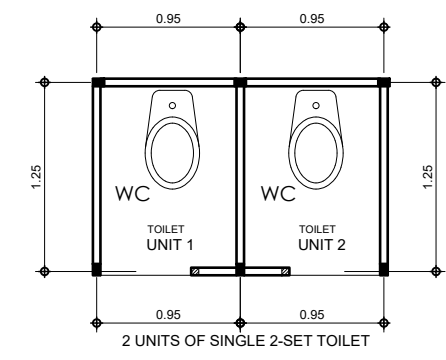


8
A-05 SCALE 1:100 M
SINGLE 2-SET TOILET FLOOR PLAN

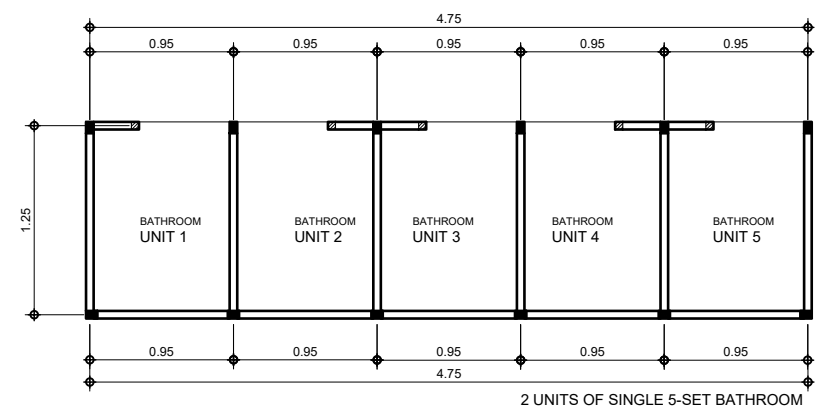

3
A-05 SCALE 1:100 M
SINGLE 5-SET BATHROOM FLOOR PLAN

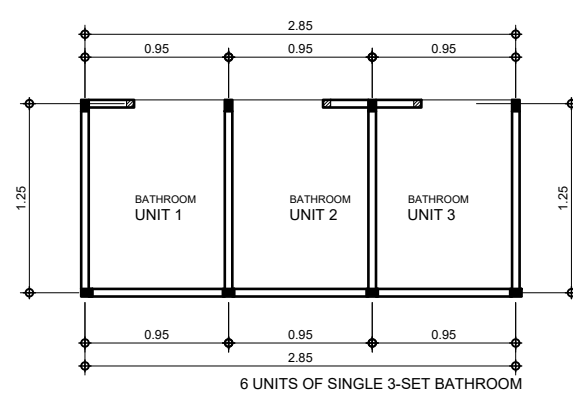

6
A-05 SCALE 1:100 M
SINGLE 3-SET BATHROOM FLOOR PLAN

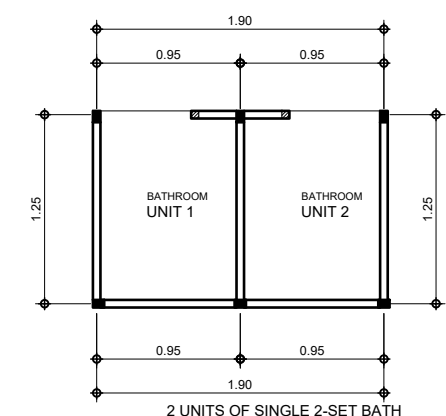

9
A-05 SCALE 1:100 M
SINGLE 2-SET BATHROOM FLOOR PLAN



SOUTHERN LEYTE STATE UNIVERSITY
SOGOD, SOUTHERN LEYTE
www.slsuonline.edu.ph
email: sstmaincampus@gmail.com
telefax: (053) 577-3229

PREPARED BY:
KURT ALEX ROMERO DRAFTSMAN-DJT
MARLOU CASTIGON DRAFTSMAN-DJT
MELI ANN B. TAGUD DRAFTSMAN-DJT
ELDIE L. MACUTO DRAFTSMAN-DJT
JASON P. JAYAGAN DRAFTSMAN-DJT


REVIEWED BY:
ENGR. RYAN A. MACUTO CAMPUS ENGINEER DESIGNATE

PROJECT:
MAKESHIFT TOILET, BATHROOM AND KITCHEN FOR SCUAA DELEGATES
LOCATION: SLSU-MAIN CAMPUS, SAN ROQUE, SOGOD SOUTHERN LEYTE


OWNER:
SOUTHERN LEYTE STATE UNIVERSITY
ADDRESS: SOGOD, SOUTHERN LEYTE

APPROVED AS PER PLAN:
PROSE IVY G. YEPES, Ed. D.
UNIVERSITY PRESIDENT


SHEET CONTENT
AS SHOWN
CHECKED: _____ DRAWN: _____ SCALE: AS SHOWN @ 20x30
APPROVED: _____ DATE: _____ PROJ. NO. A-05

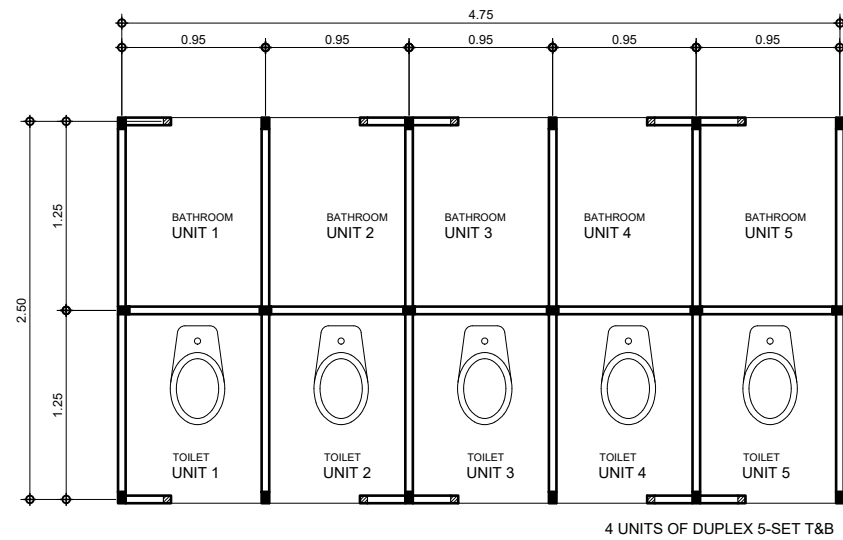


1
A-05 SCALE 1:100 M
DUPLEX 5-SET T&B FLOOR PLAN

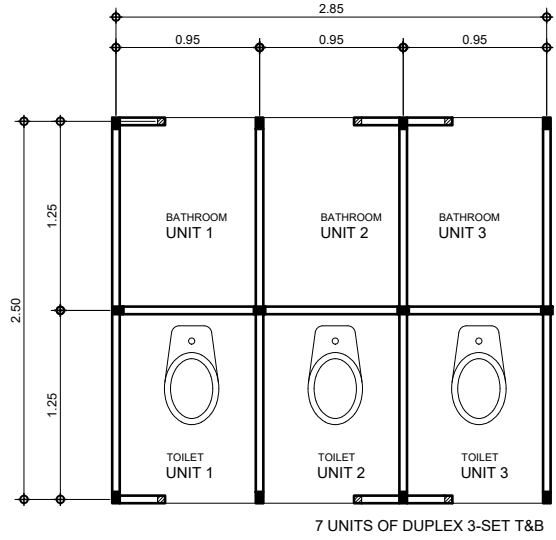


4
A-05 SCALE 1:100 M
DUPLEX 3-SET T&B FLOOR PLAN

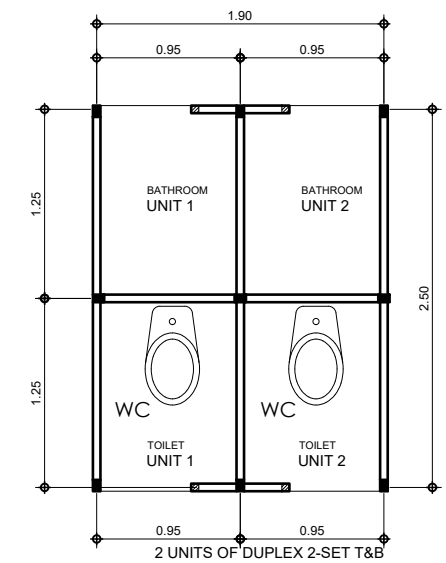


7
A-05 SCALE 1:100 M
DUPLEX 2-SET T&B FLOOR PLAN

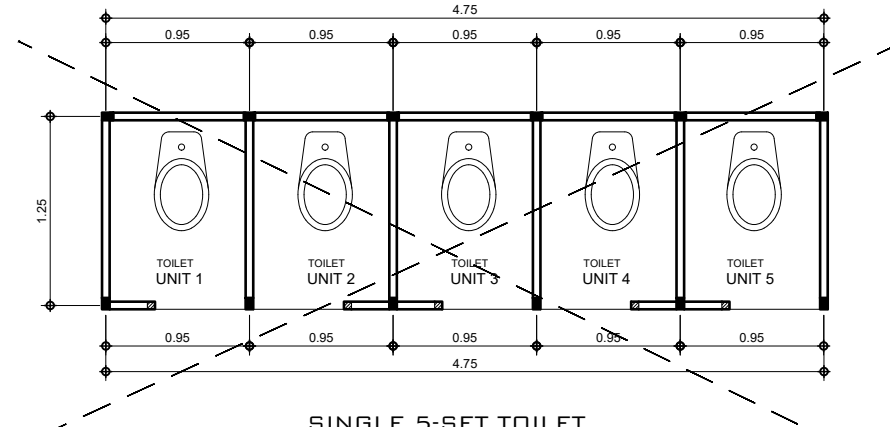


2
A-05 SCALE 1:100 M
SINGLE 5-SET TOILET FLOOR PLAN

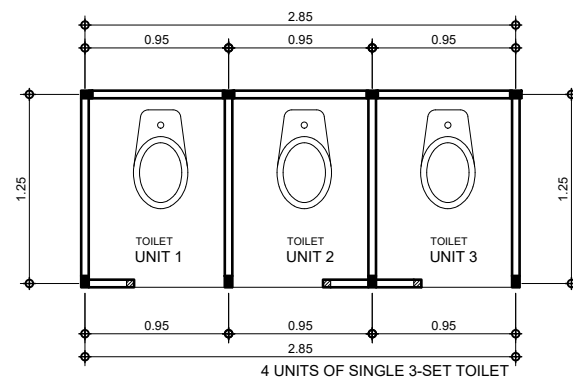


5
A-05 SCALE 1:100 M
SINGLE 3-SET TOILET FLOOR PLAN

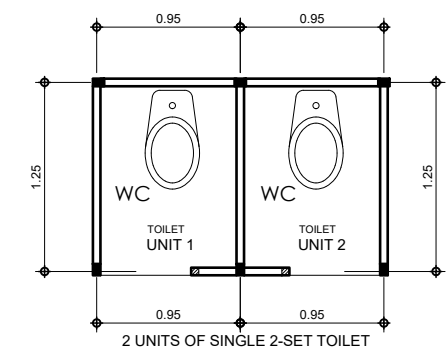


8
A-05 SCALE 1:100 M
SINGLE 2-SET TOILET FLOOR PLAN

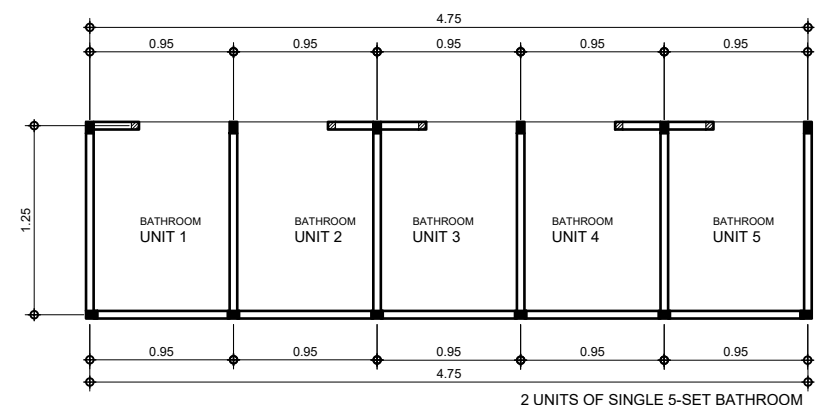

3
A-05 SCALE 1:100 M
SINGLE 5-SET BATHROOM FLOOR PLAN

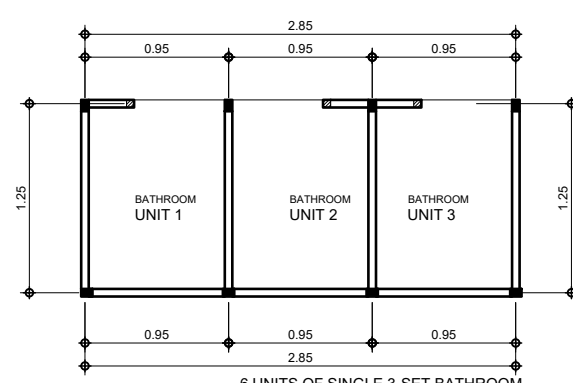

6
A-05 SCALE 1:100 M
SINGLE 3-SET BATHROOM FLOOR PLAN

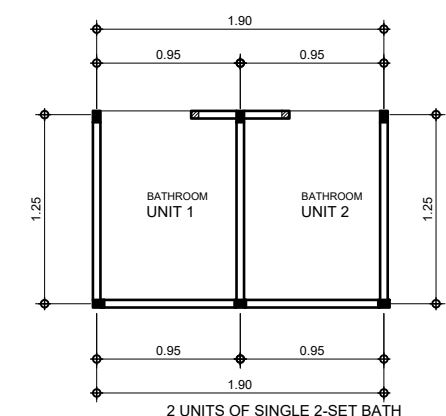

9
A-05 SCALE 1:100 M
SINGLE 2-SET BATHROOM FLOOR PLAN



SOUTHERN LEYTE STATE UNIVERSITY
SOGOD, SOUTHERN LEYTE
www.slsuonline.edu.ph
email: sstmaincampus@gmail.com
telefax: (053) 577-3229

PREPARED BY:
KURT ALEX ROMERO DRAFTSMAN-DJT
MARLOU CASTIGON DRAFTSMAN-DJT
MELI ANN B. TAGUD DRAFTSMAN-DJT
ELDIE L. MACUTO DRAFTSMAN-DJT
JASON P. JAYAGAN DRAFTSMAN-DJT


REVIEWED BY:
ENGR. RYAN A. MACUTO CAMPUS ENGINEER DESIGNATE

PROJECT:
MAKESHIFT TOILET, BATHROOM AND KITCHEN FOR SCUAA DELEGATES
LOCATION: SLSU-MAIN CAMPUS, SAN ROQUE, SOGOD SOUTHERN LEYTE


OWNER:
SOUTHERN LEYTE STATE UNIVERSITY
ADDRESS: SOGOD, SOUTHERN LEYTE

APPROVED AS PER PLAN:
PROSE IVY G. YEPES, Ed. D.
UNIVERSITY PRESIDENT


SHEET CONTENT
AS SHOWN
CHECKED: _____ DRAWN: _____ SCALE: AS SHOWN @ 20x30
APPROVED: _____ DATE: _____ PROJ. NO. A-05

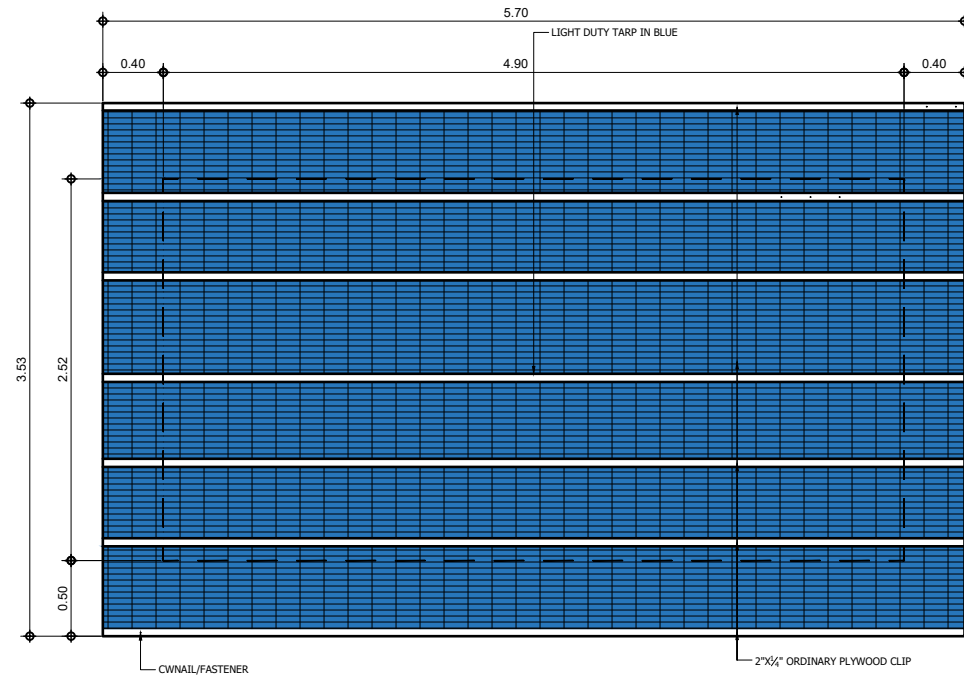


1
A-06
**DUPLEX 5-SET T&B
ROOF PLAN**
SCALE 1:100 M

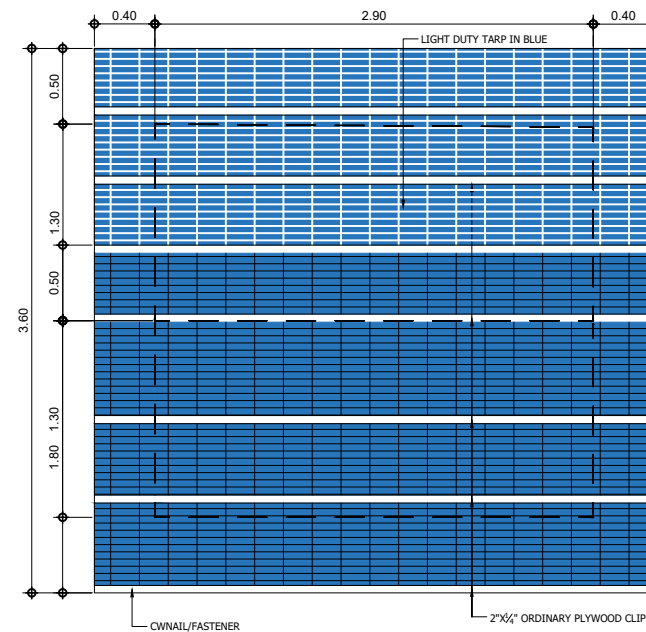


2
A-06
**DUPLEX 3-SET T&B
ROOF PLAN**
SCALE 1:100 M

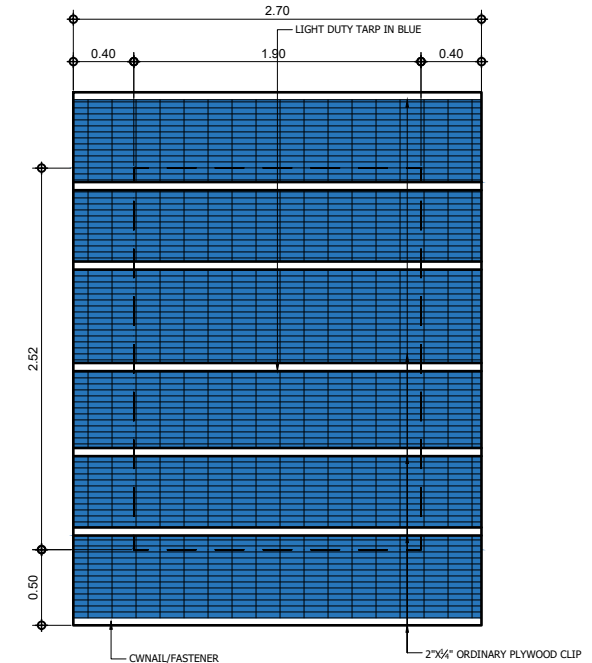


3
A-06
**DUPLEX 3-SET T&B
ROOF PLAN**
SCALE 1:100 M

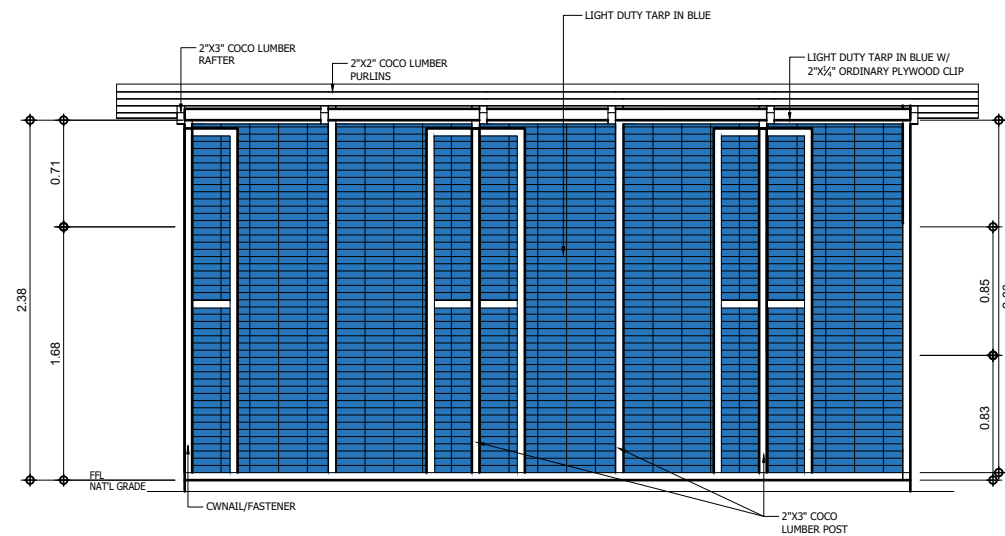

4
A-06
**DUPLEX 5-SET T&B
FRONT ELEVATION**
SCALE 1:100 M

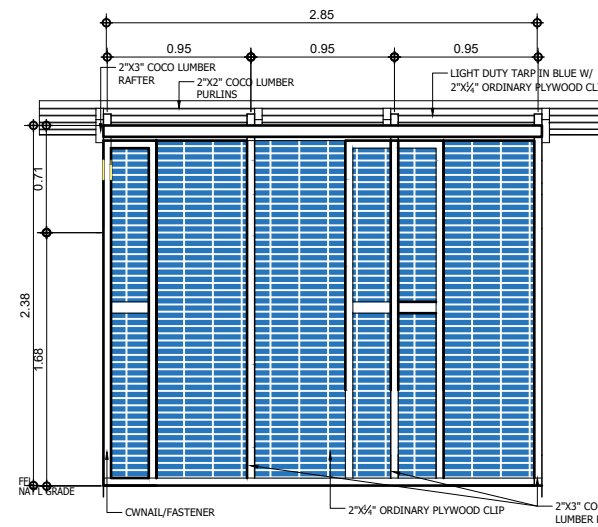

5
A-06
**DUPLEX 3-SET T&B
FRONT ELEVATION**
SCALE 1:100 M

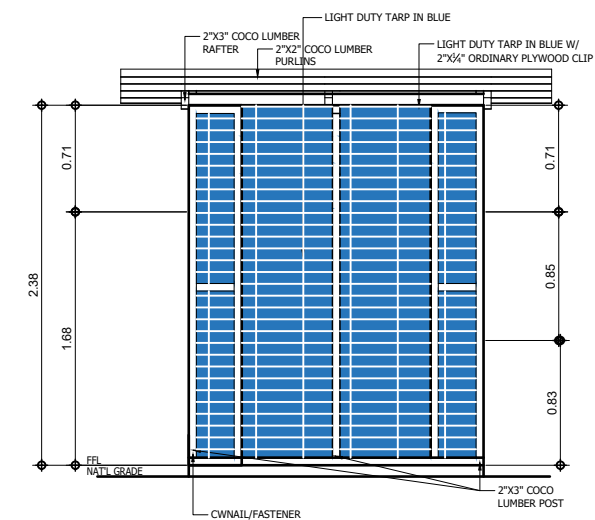

6
A-06
**DUPLEX 2-SET T&B
FRONT ELEVATION**
SCALE 1:100 M



**SOUTHERN LEYTE STATE
UNIVERSITY**
SOGOD, SOUTHERN LEYTE
www.slsuonline.edu.ph
email: ssumaincampus@gmail.com
telefax: (053) 577-3229

PREPARED BY:
KURT ALEX ROMERO
DRAFTSMAN-OJT
MARLOU CASTIGON
DRAFTSMAN-OJT
MELI ANN B. TAGUD
DRAFTSMAN-OJT


REVIEWED BY:
ELDIE L. MACUTO
DRAFTSMAN-OJT
JASON P. JAYAGAN
DRAFTSMAN-OJT
ENGR. RYAN A. MACUTO
CAMPUS ENGINEER DESIGNATE

PROJECT:
**MAKESHIFT TOILET, BATHROOM
AND KITCHEN FOR SCUAA
DELEGATES**
LOCATION: SLSU-MAIN CAMPUS, SAN ROQUE, SOGOD SOUTHERN LEYTE


OWNER:
SOUTHERN LEYTE STATE UNIVERSITY
ADDRESS: SOGOD, SOUTHERN LEYTE

APPROVED AS PER PLAN:
PROSE IVY G. YEPES, Ed. D.
UNIVERSITY PRESIDENT


SHEET CONTENT
AS SHOWN
CHECKED : _____ DRAWN : _____ SCALE
APPROVED : _____ DATE : _____ AS SHOWN @ 20x30
SHEET NO.
A-06
PROJ. NO.

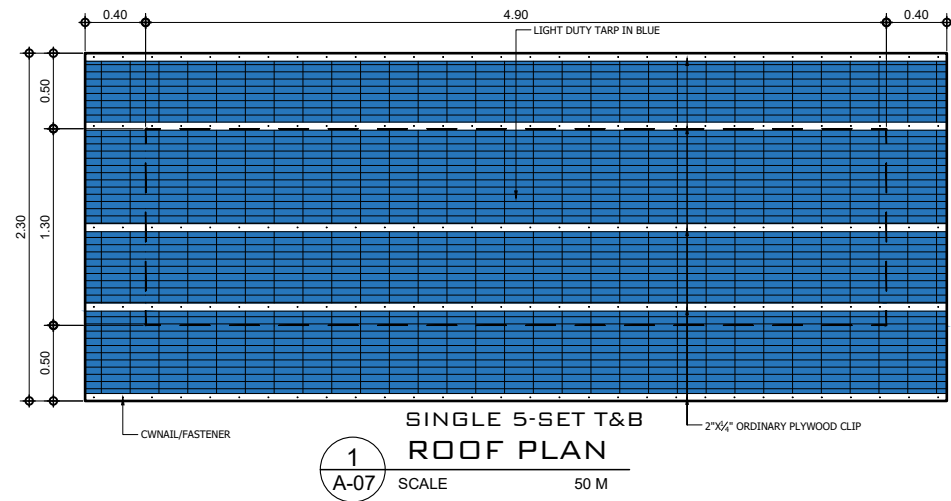


1
A-07
SCALE 50 M
SINGLE 5-SET T&B
ROOF PLAN

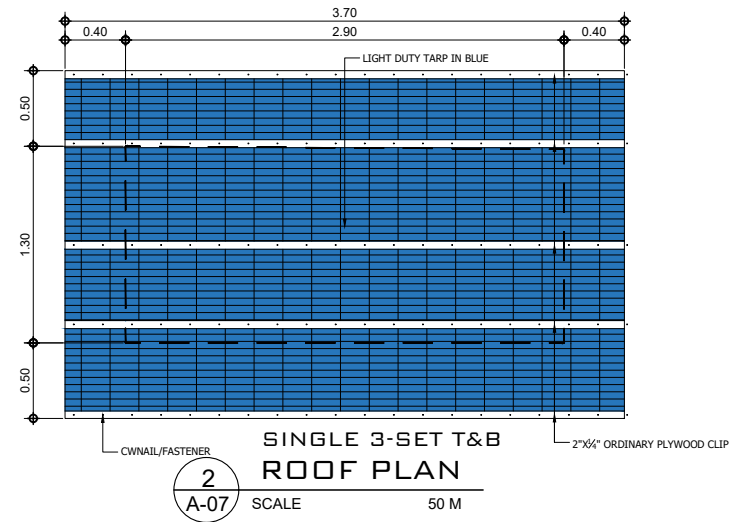


2
A-07
SCALE 50 M
SINGLE 3-SET T&B
ROOF PLAN

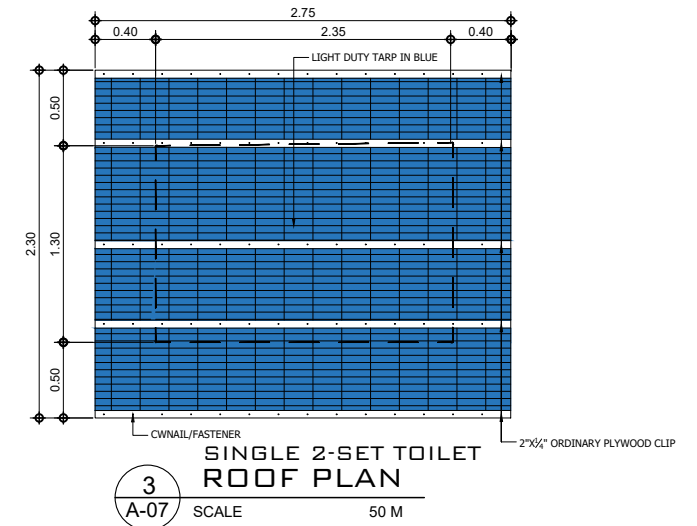


3
A-07
SCALE 50 M
SINGLE 2-SET TOILET
ROOF PLAN

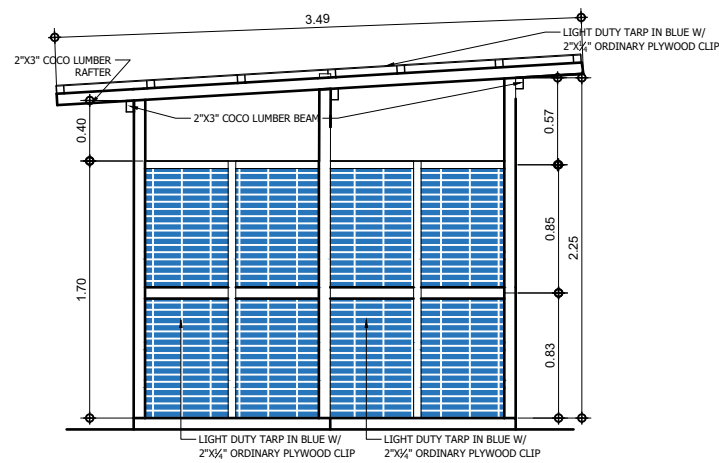


4
A-07
SCALE 50 M
SIDE ELEVATION FOR DUPLEX T&B

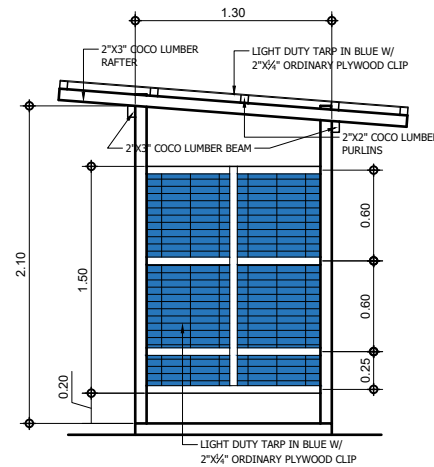


5
A-07
SCALE 50 M
SIDE ELEVATION FOR SINGLE T&B

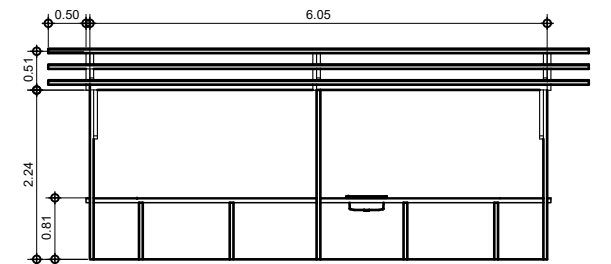


6
A-07
SCALE 1:100 M
MAKESHIFT KITCHEN
FRONT ELEVATION

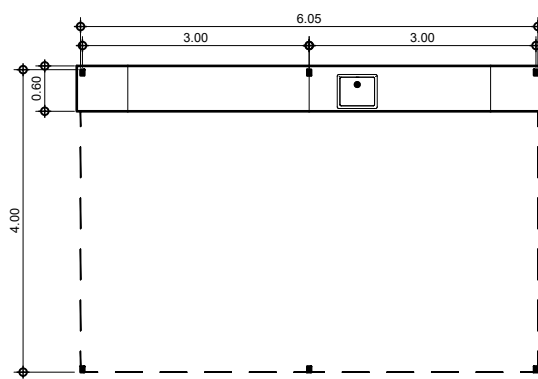

7
A-07
SCALE 1:100 M
MAKESHIFT KITCHEN
FLOOR PLAN

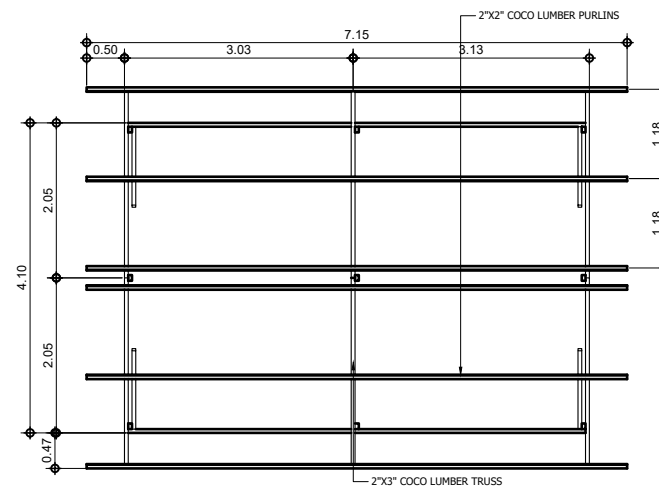

7
A-07
SCALE 1:100 M
MAKESHIFT KITCHEN
ROOF PLAN

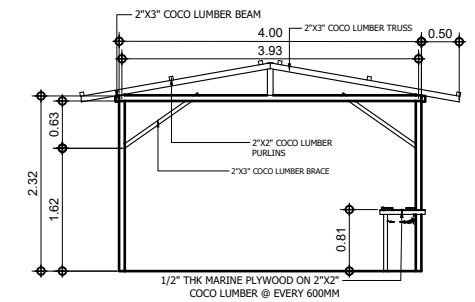

8
A-07
SCALE 1:100 M
MAKESHIFT KITCHEN
FRONT ELEVATION



SOUTHERN LEYTE STATE UNIVERSITY
SOGOD, SOUTHERN LEYTE
www.slsuonline.edu.ph
email: ssumaincampus@gmail.com
telefax: (053) 577-3299

PREPARED BY:
KURT ALEX ROMERO DRAFTSMAN-GJT
MARLOU CASTIGON DRAFTSMAN-GJT
MELI ANN B. TAGUD DRAFTSMAN-GJT
ELDIE L. MACUTO DRAFTSMAN-GJT
JASON P. JAYAGAN DRAFTSMAN-GJT


REVIEWED BY:
ENGR. RYAN A. MACUTO
CAMPUS ENGINEER DESIGNATE

PROJECT:
MAKESHIFT TOILET, BATHROOM AND KITCHEN FOR SCJAA DELEGATES
LOCATION: SLSU-MAIN CAMPUS, SAN ROQUE, SOGOD SOUTHERN LEYTE


OWNER:
SOUTHERN LEYTE STATE UNIVERSITY
ADDRESS: SOGOD, SOUTHERN LEYTE

APPROVED AS PER PLAN:
PROSE IVY G. YEPES, Ed. D.
UNIVERSITY PRESIDENT


SHEET CONTENT
AS SHOWN
CHECKED: _____ DRAWN: _____ SCALE: AS SHOWN @ 20x30
APPROVED: _____ DATE: _____ PROJ. NO. A-07

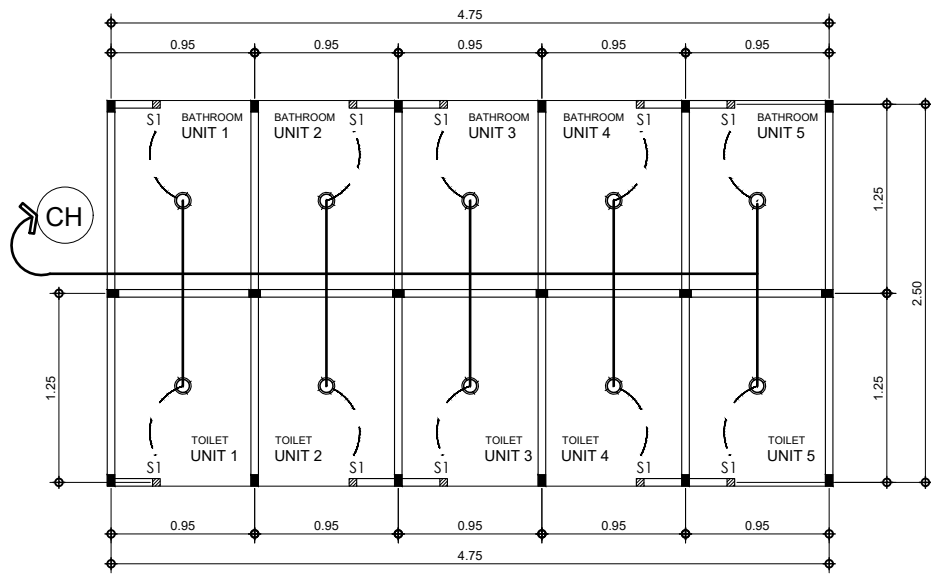


1
E-01 **DUPLEX 5-SET T&B**
ELECTRICAL LIGHTING LAYOUT
SCALE 1:50 M

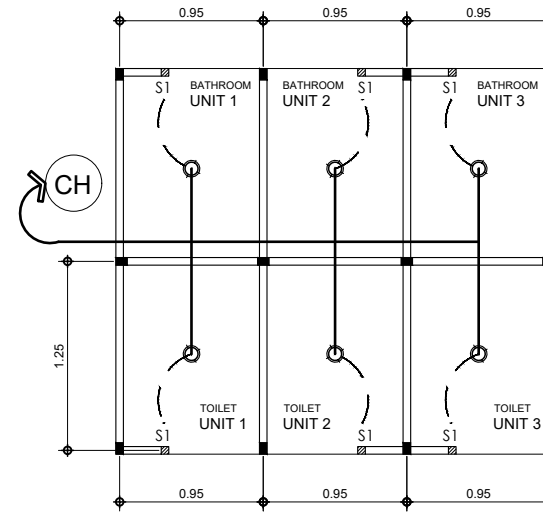


2
E-01 **DUPLEX 3-SET T&B**
ELECTRICAL LIGHTING LAYOUT
SCALE 1:50 M

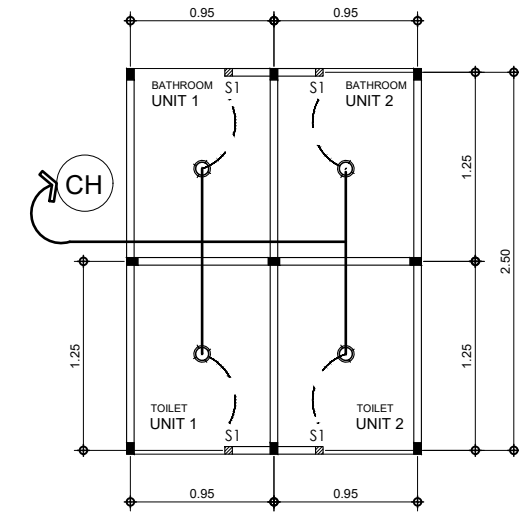


3
E-01 **DUPLEX 2-SET T&B**
ELECTRICAL LIGHTING LAYOUT
SCALE 1:50 M

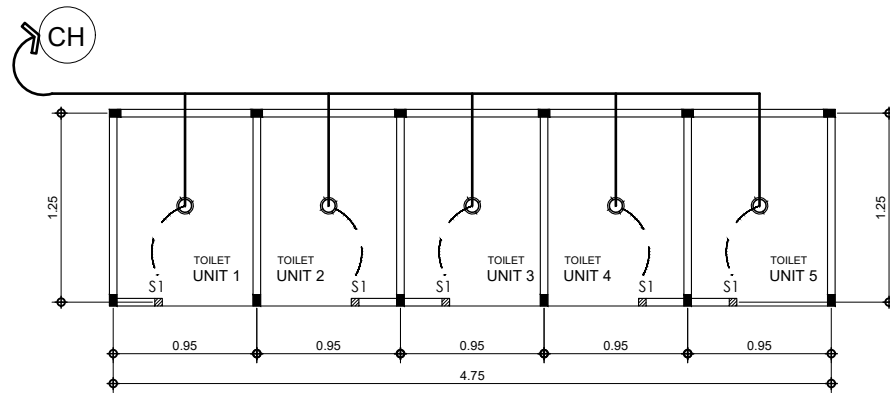


4
E-01 **SINGLE 5-SET TOILET**
ELECTRICAL LIGHTING LAYOUT
SCALE 1:50 M

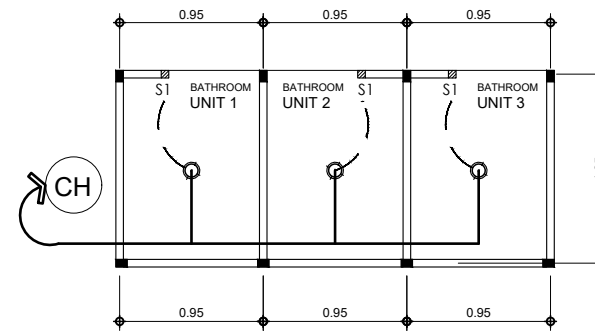


5
E-01 **SINGLE 3-SET BATH**
ELECTRICAL LIGHTING LAYOUT
SCALE 1:50 M

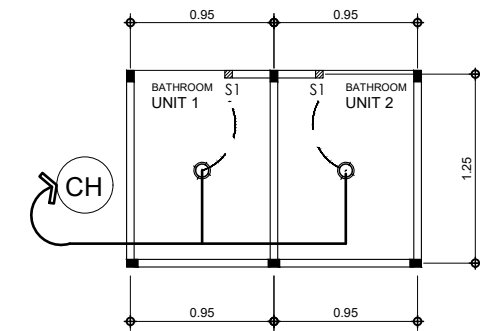


6
E-01 **SINGLE 2-SET BATH**
ELECTRICAL LIGHTING LAYOUT
SCALE 1:50 M

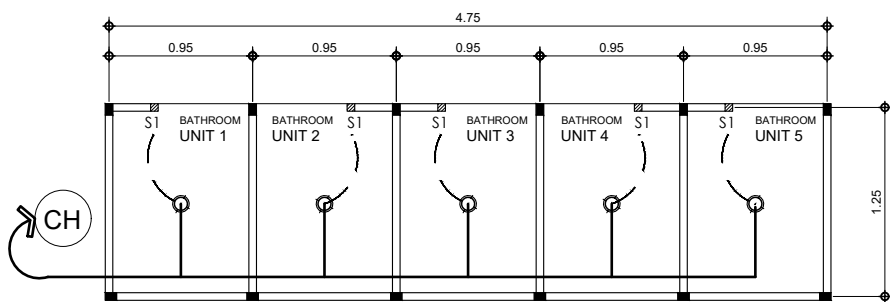

7
E-01 **SINGLE 5-SET BATH**
ELECTRICAL LIGHTING LAYOUT
SCALE 1:50 M

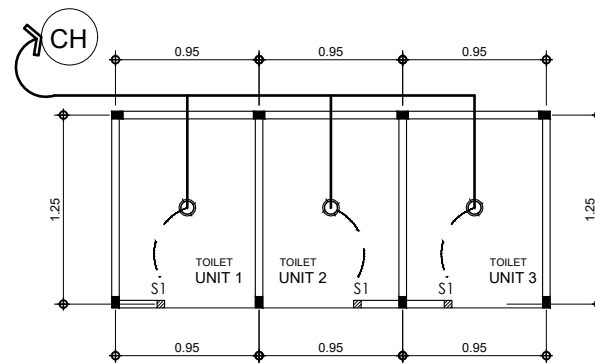

8
E-01 **SINGLE 3-SET TOILET**
ELECTRICAL LIGHTING LAYOUT
SCALE 1:50 M

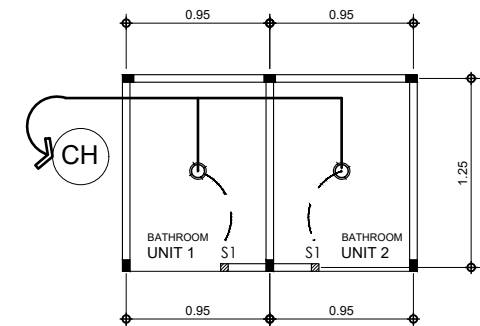

9
E-01 **SINGLE 2-SET TOILET**
ELECTRICAL LIGHTING LAYOUT
SCALE 1:50 M



SOUTHERN LEYTE STATE UNIVERSITY
SOGOD, SOUTHERN LEYTE
www.slsuonline.edu.ph
email: ssumaincampus@gmail.com
telefax: (053) 577-3299

PREPARED BY:
KURT ALEX ROMERO DRAFTSMAN-OJT
ELDIE L. MACUTO DRAFTSMAN-OJT
MARLOU CASTIGON DRAFTSMAN-OJT
JASON P. JAYAGAN DRAFTSMAN-OJT
MELI ANN B. TAGUD DRAFTSMAN-OJT


REVIEWED BY:
ENGR. RYAN A. MACUTO
CAMPUS ENGINEER DESIGNATE

PROJECT:
MAKESHIFT TOILET, BATHROOM AND KITCHEN FOR SCUAA DELEGATES
LOCATION: SLSU-MAIN CAMPUS, SAN ROQUE, SOGOD SOUTHERN LEYTE


OWNER:
SOUTHERN LEYTE STATE UNIVERSITY
ADDRESS: SOGOD, SOUTHERN LEYTE

APPROVED AS PER PLAN:
PROSE IVY G. YEPES, Ed. D.
UNIVERSITY PRESIDENT


SHEET CONTENT
AS SHOWN
CHECKED: _____ DRAWN: _____ SCALE: _____
APPROVED: _____ DATE: _____ AS SHOWN @ 20x30
SHEET NO. E-01
PROJ. NO. _____

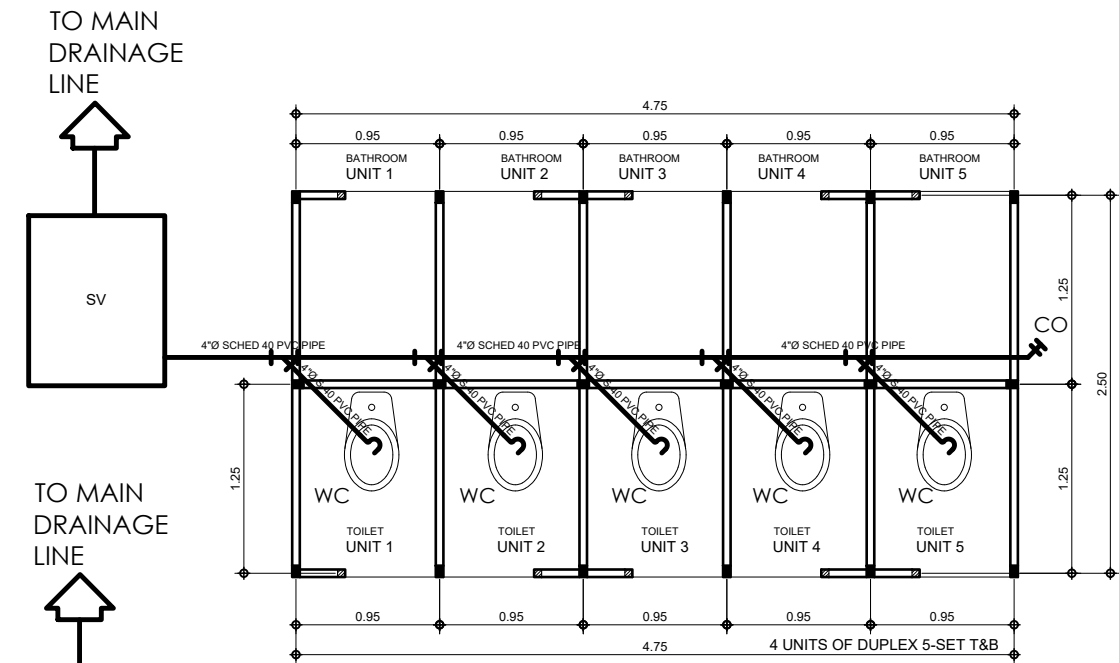


1
P-01
**DUPLEX 5-SET T&B
SANITARY LAYOUT**
SCALE 1:50 M

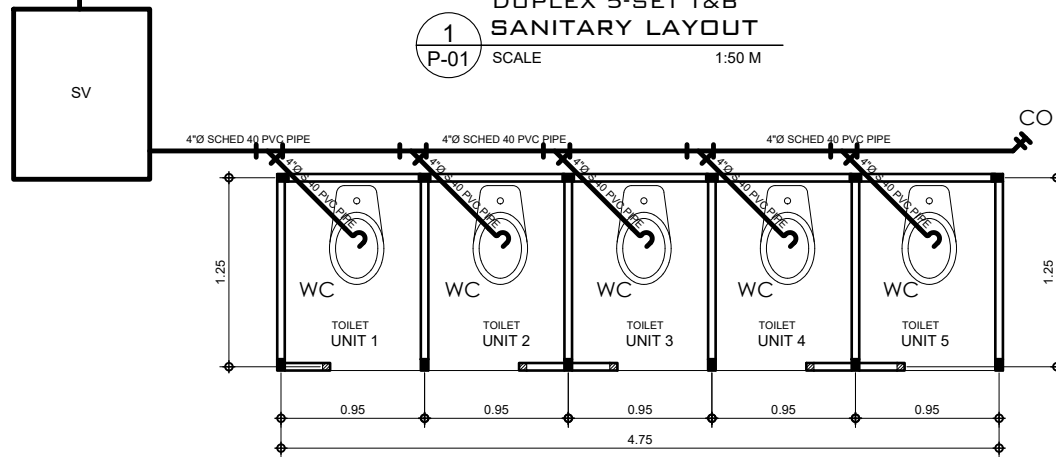


4
P-01
**SINGLE 5-SET TOILET
SANITARY LAYOUT**
SCALE 1:50 M

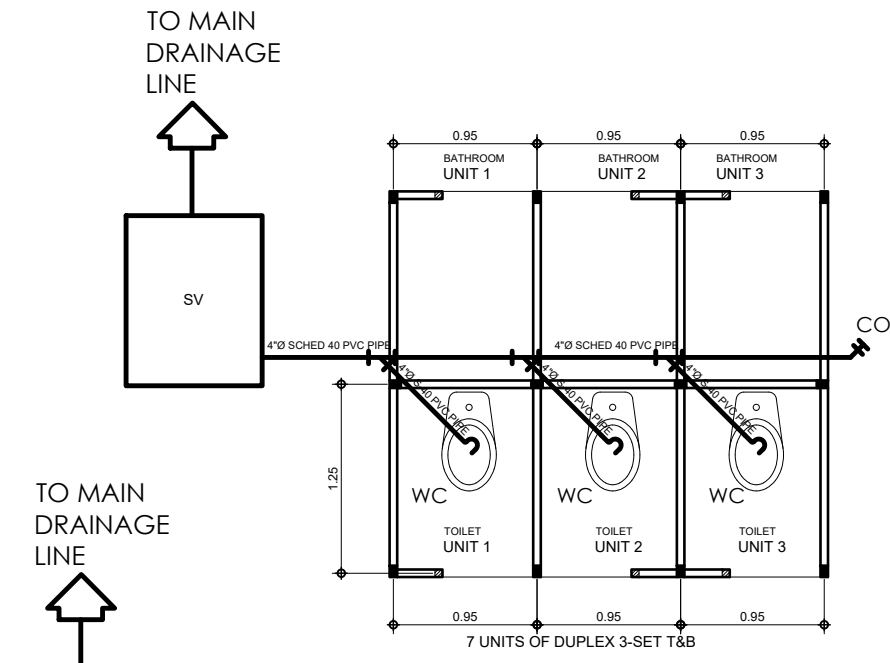


2
P-01
**DUPLEX 3-SET T&B
SANITARY LAYOUT**
SCALE 1:50 M

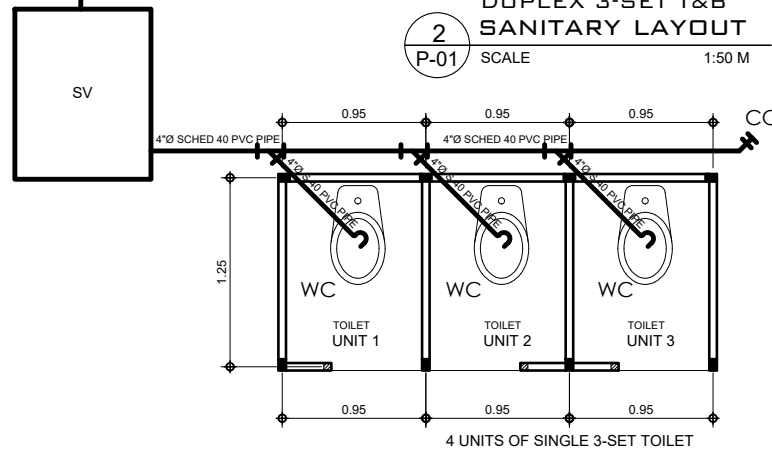


5
P-01
**SINGLE 5-SET TOILET
SANITARY LAYOUT**
SCALE 1:50 M

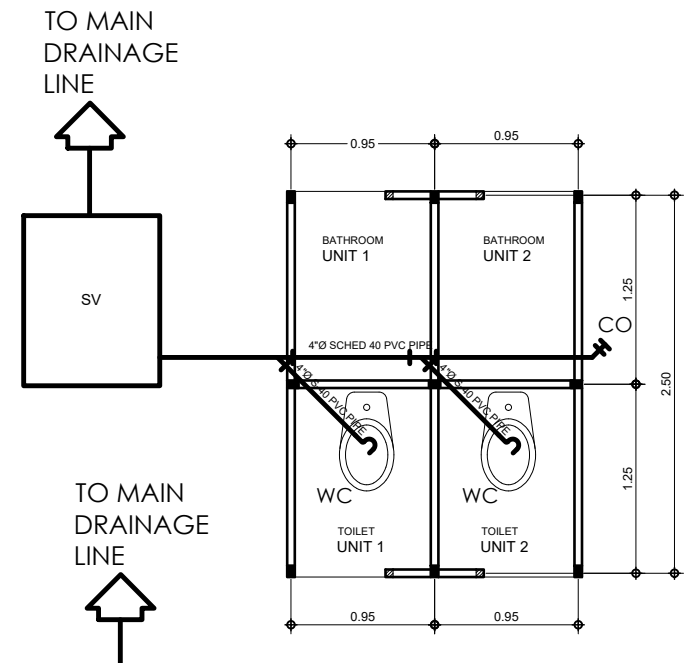


3
P-01
**2 UNITS OF DUPLEX 2-SET T&B
SANITARY LAYOUT**
SCALE 1:50 M

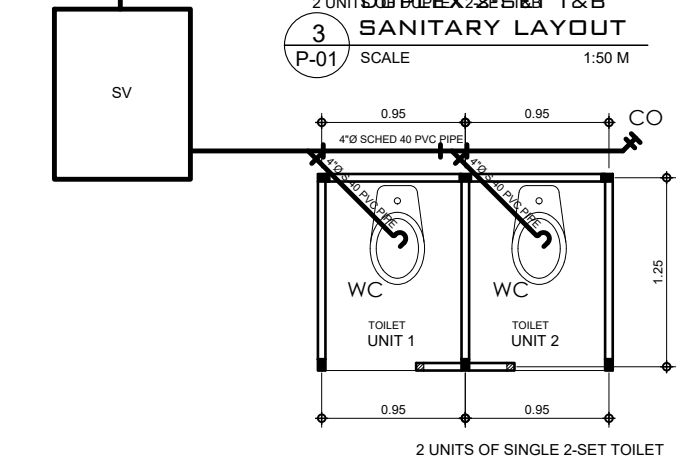


6
P-01
**SINGLE 5-SET TOILET
SANITARY LAYOUT**
SCALE 1:50 M

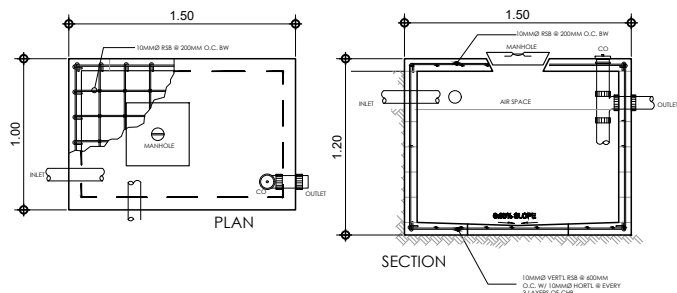

7
P-01
SEPTIC VAULT DETAIL
SCALE 1:50 M

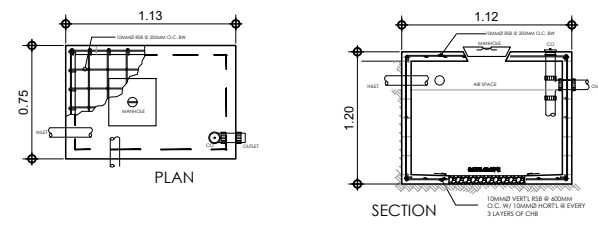

8
P-01
SEPTIC VAULT DETAIL
SCALE 1:50 M

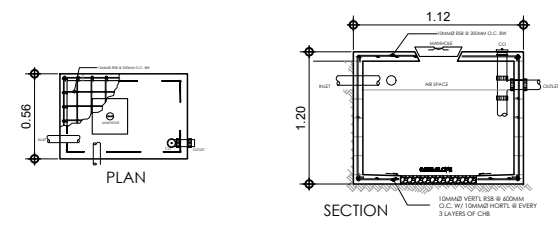

9
P-01
SEPTIC VAULT DETAIL
SCALE 1:50 M



**SOUTHERN LEYTE STATE
UNIVERSITY**
SOGOD, SOUTHERN LEYTE
www.slsuonline.edu.ph
email: ssumaincampus@gmail.com
telefax: (053) 577-3229

PREPARED BY:
KURT ALEX ROMERO
DRAFTSMAN-DJT
MARLOU CASTIGON
DRAFTSMAN-DJT
MELI ANN B. TAGUD
DRAFTSMAN-DJT


REVIEWED BY:
ELDIE L. MACUTO
DRAFTSMAN-DJT
JASON P. JAYAGAN
DRAFTSMAN-DJT
ENGR. RYAN A. MACUTO
CAMPUS ENGINEER DESIGNATE

PROJECT:
**MAKESHIFT TOILET, BATHROOM
AND KITCHEN FOR SCUAA
DELEGATES**
LOCATION: SLSU-MAIN CAMPUS, SAN ROQUE, SOGOD SOUTHERN LEYTE


OWNER:
SOUTHERN LEYTE STATE UNIVERSITY
ADDRESS: SOGOD, SOUTHERN LEYTE

APPROVED AS PER PLAN:
PROSE IVY G. YEPES, Ed. D.
UNIVERSITY PRESIDENT


SHEET CONTENT
AS SHOWN
CHECKED : _____ DRAWN : _____ SCALE : _____
APPROVED : _____ DATE : _____ AS SHOWN @ 20x30
SHEET NO. P-01
PROJ. NO. _____

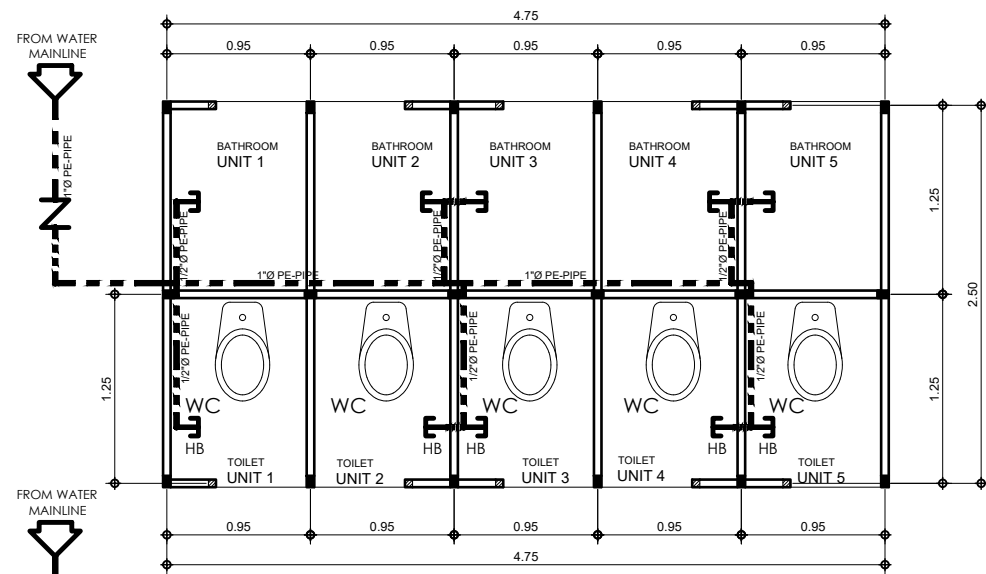


1
P-02
DUPEX 5-SET T&B
PLUMBING LAYOUT
SCALE 1:50 M

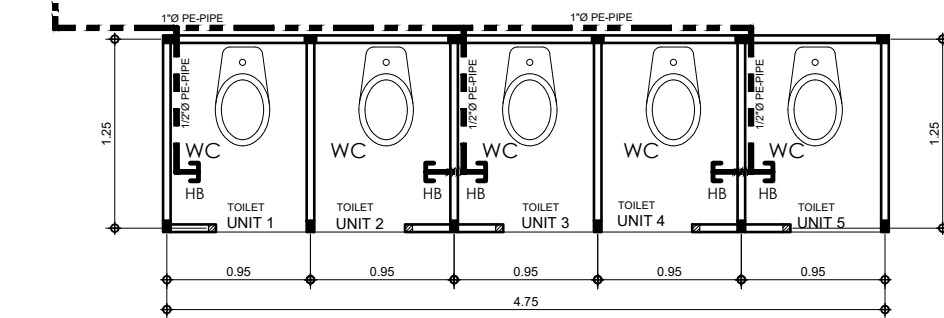


4
P-02
SINGLE 5-SET TOILET
PLUMBING LAYOUT
SCALE 1:50 M

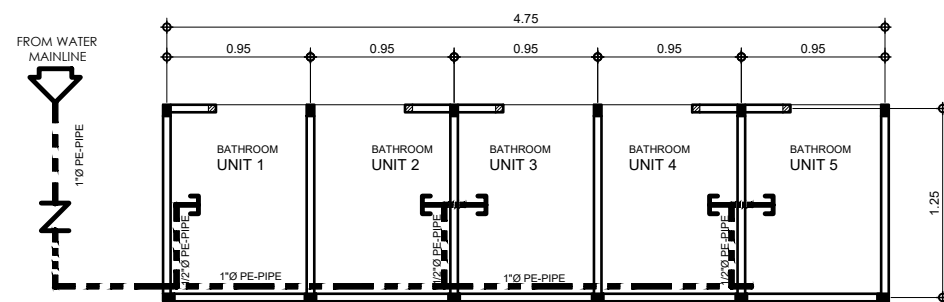


7
P-02
SINGLE 5-SET BATH
PLUMBING LAYOUT
SCALE 1:50 M

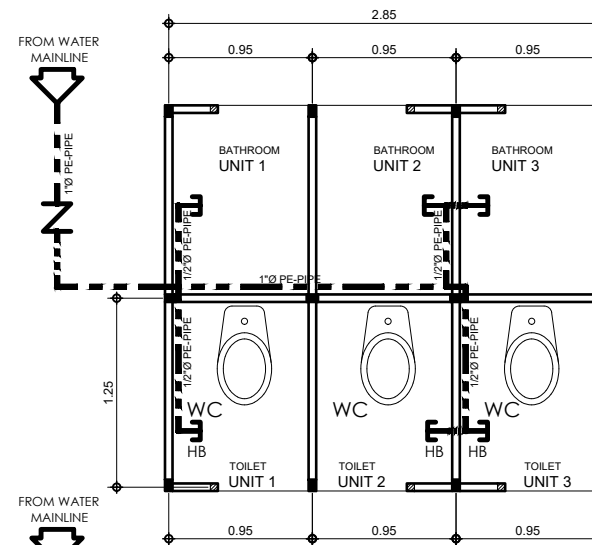


2
P-02
DUPEX 3-SET T&B
PLUMBING LAYOUT
SCALE 1:50 M

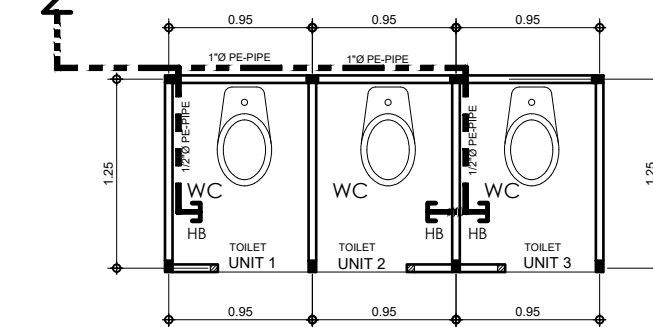


5
P-02
SINGLE 3-SET TOILET
PLUMBING LAYOUT
SCALE 1:50 M

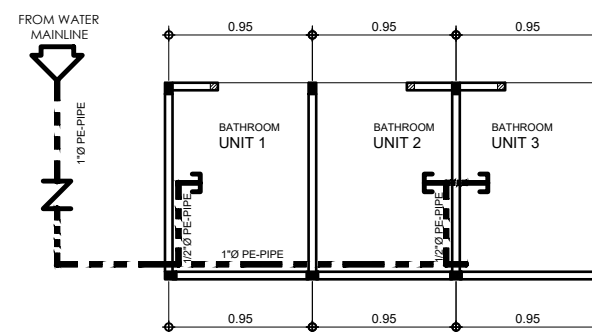


8
P-02
SINGLE 3-SET BATH
PLUMBING LAYOUT
SCALE 1:50 M

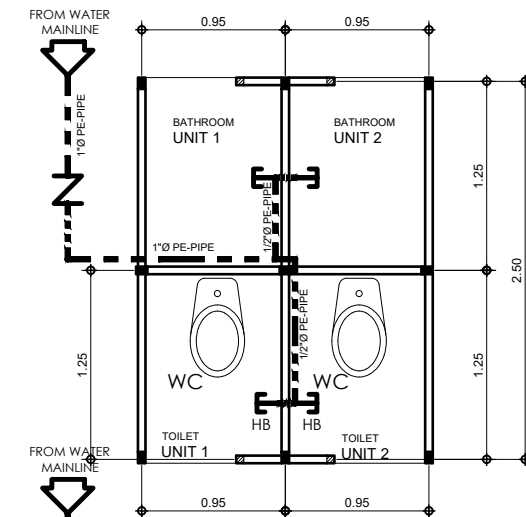

3
P-02
DUPEX 2-SET T&B
PLUMBING LAYOUT
SCALE 1:50 M

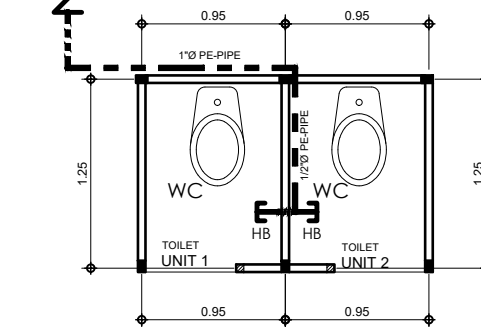

6
P-02
SINGLE 2-SET TOILET
PLUMBING LAYOUT
SCALE 1:50 M

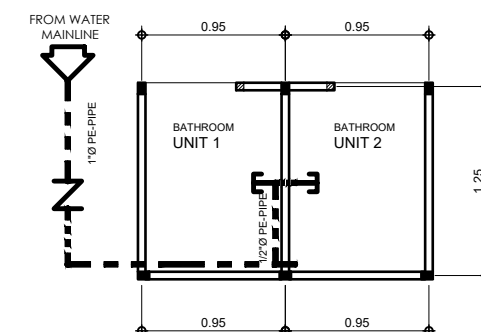

9
P-02
SINGLE 2-SET BATH
PLUMBING LAYOUT
SCALE 1:50 M



SOUTHERN LEYTE STATE UNIVERSITY
SOGOD, SOUTHERN LEYTE
www.slsuonline.edu.ph
email: sstmaincampus@gmail.com
telefax: (053) 577-3229

PREPARED BY:
KURT ALEX ROMERO DRAFTSMAN-OJT
MARLOU CASTIGON DRAFTSMAN-OJT
MELI ANN B. TAGUD DRAFTSMAN-OJT
ELDIE L. MACUTO DRAFTSMAN-OJT
JASON P. JAYAGAN DRAFTSMAN-OJT

REVIEWED BY:
ENGR. RYAN A. MACUTO
CAMPUS ENGINEER DESIGNATE

PROJECT:
MAKESHIFT TOILET, BATHROOM AND KITCHEN FOR SCUAA DELEGATES

LOCATION: SLSU-MAIN CAMPUS, SAN ROQUE, SOGOD SOUTHERN LEYTE

OWNER:
SOUTHERN LEYTE STATE UNIVERSITY

ADDRESS: SOGOD, SOUTHERN LEYTE

APPROVED AS PER PLAN:
PROSE IVY G. YEPES, Ed. D.
UNIVERSITY PRESIDENT

SHEET CONTENT
AS SHOWN

CHECKED: _____ DRAWN: _____ SCALE: AS SHOWN @ 20x30
APPROVED: _____ DATE: _____

SHEET NO.
P-02
PROJ. NO.