



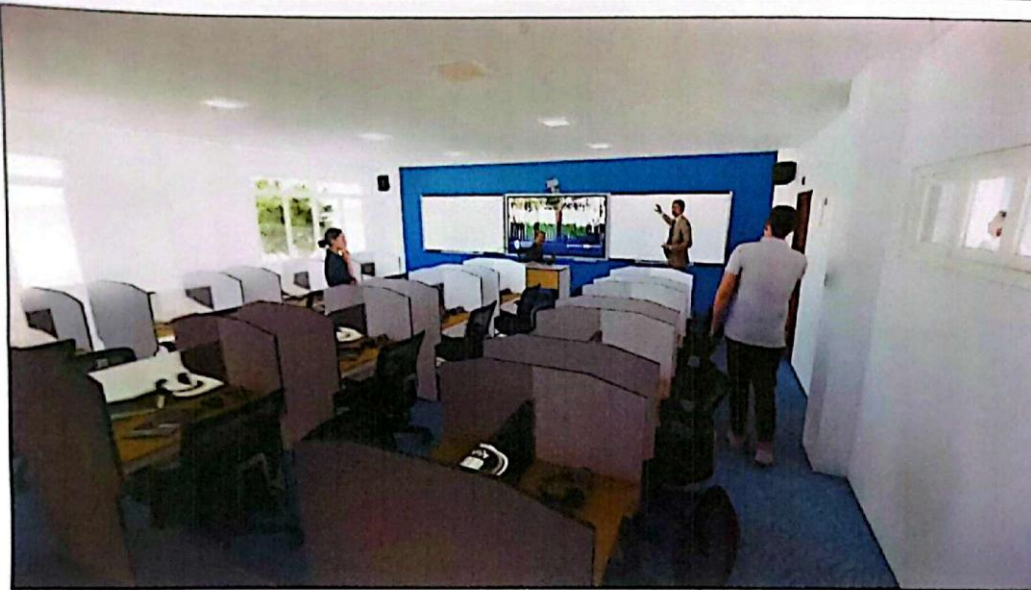

PERSPECTIVE
SCALE 1 : 70.

 SOUTHERN LEYTE STATE UNIVERSITY Office of the President Office of the Vice President	DRAWN BY: JASON M. VIAGAS ENGINEER ROMEL M. VIAGAS ENGINEER	PREPARED BY: AR. JAMES P. C. VANGELISTA, UAP PROJECT DEVELOPMENT OFFICER II ENGR. MEYMA P. OLIVERON, RMP PROJECT DEVELOPMENT OFFICER I ENGR. RYAN A. MACUTO, GREEN ADP-AA PROJECT DEVELOPMENT OFFICER III	PROJECT: RENOVATION OF SPEECH LABORATORY LOCATION: SLISJ-SOGOD CAMPUS, SAN ROQUE, SOGOD SOUTHERN LEYTE	OWNER: SOUTHERN LEYTE STATE UNIVERSITY ADDRESS: SLISJ-SOGOD CAMPUS, SAN ROQUE, SOGOD SOUTHERN LEYTE	APPROVED AS PER PLAN:  JUDE A. DUARTE, DPA UNIVERSITY PRESIDENT	SHEET CONTENT: AS SHOWN CHECKED: ☐ DRAWN: ☐ APPROVED: ☐ DATE: ☐ SCALE: AS SHOWN	SHEET NO.: A-01 PROJ. NO.:
---	---	---	---	--	--	---	--

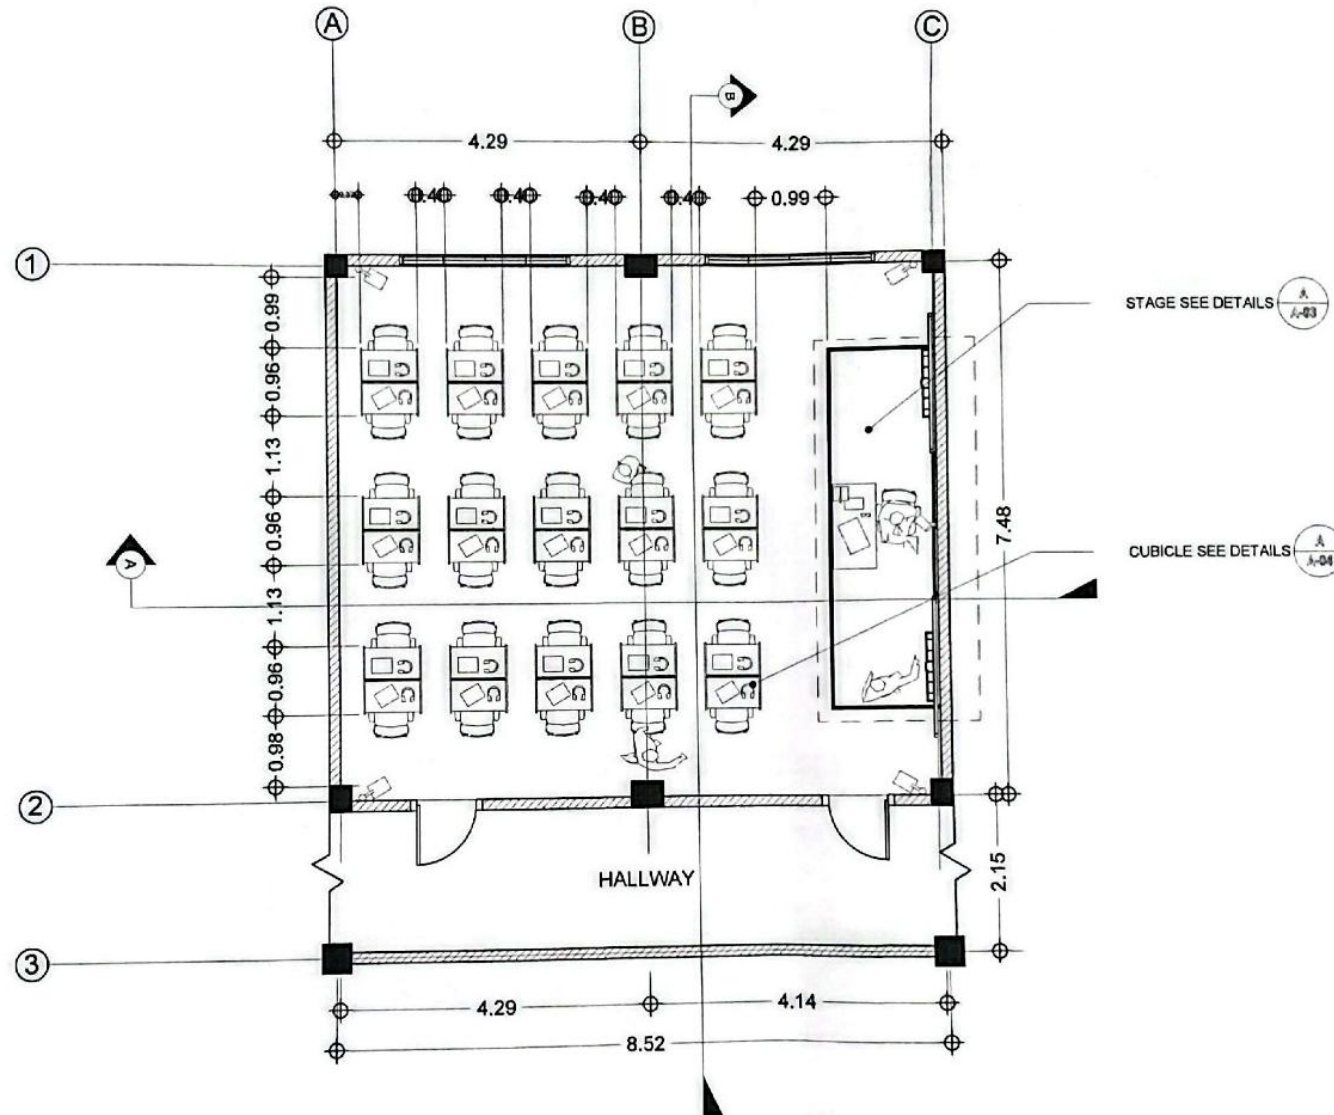

FLOOR PLAN
SCALE 1 : 75



DRAWN BY
JASON M. WAGAS
RICE 07/19
RONALD A. WAGAS
RICE 07/19


PREPARED BY
AR. JAMES PAUL VANGELISTA, UAP
PROJECT DEVELOPMENT OFFICER I
ENGR. KEVIN P. OLIVERA, RMP
PROJECT DEVELOPMENT OFFICER I
ENGR. RYAN A. MACUTO, GREENE ADP-AA
PROJECT DEVELOPMENT OFFICER II

PROJECT
RENOVATION OF SPEECH
LABORATORY
LOCATION: SLSU-SOGOD CAMPUS, SAN ROGUE, SOGOD SOUTHERN LEYTE

OWNER
SOUTHERN LEYTE STATE UNIVERSITY
ADDRESS: SLSU-SOGOD CAMPUS, SAN ROGUE, SOGOD SOUTHERN LEYTE


APPROVED AS PER PLAN
JUDE A. BUARTE, OPA
UNIVERSITY PRESIDENT

SHEET CONTENT
AS SHOWN
CHECKED: DATE: SCALE: AS SHOWN
SHEET NO. A-02
PROJECT NO.

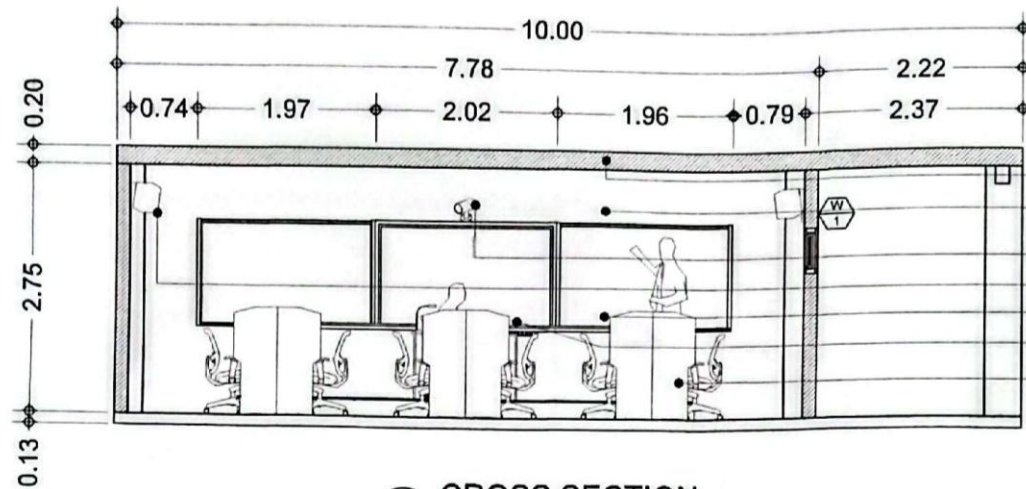

CROSS SECTION
SCALE 1 : 60 M.

CEILING
PAINTED WALL SMOOTH FINISH MATTE
WHITE (REPAINT)
CCTV
SPEAKER
WHITEBOARD
INTERACTIVE MONITOR
CUBICLE (SEE DETAILS)

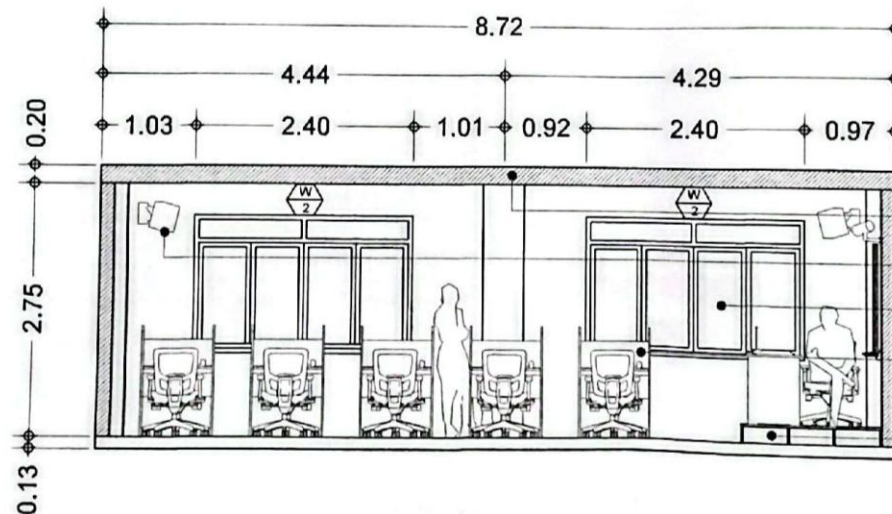

LONGITUDINAL SECTION
SCALE 1 : 60 M.

CEILING
SPEAKER
EXISTING WINDOW
CUBICLE (SEE DETAILS)
STAGE (SEE DETAILS)



DRAWN BY
JASON M. WAGAS
RICHIE
ROMEL A. WAGAS
REGISTRATION


PREPARED BY
AR. JAMES R. GABRIELISTA, UAP
PROJECT DEVELOPMENT OFFICER I
ENGR. RYAN A. MACUTO, GREENE ACP-AA
PROJECT DEVELOPMENT OFFICER II

PROJECT
RENOVATION OF SPEECH
LABORATORY
LOCATION: SLBU-SOGOD CAMPUS, SAN ROQUE, SOGOD SOUTHERN LEYTE



OWNER
SOUTHERN LEYTE STATE UNIVERSITY
ADDRESS: SLBU-SOGOD CAMPUS, SAN ROQUE, SOGOD SOUTHERN LEYTE

APPROVED AS PER PLAN
JUDE A. QUARTE, DPA
UNIVERSITY PRESIDENT

SHEET CONTENT
AS SHOWN
CHECKED: _____ DRAWN: _____ SCALE: _____
APPROVED: _____ DATE: _____ AS SHOWN: _____
SHEET NO.
A-03
PROJ. NO.

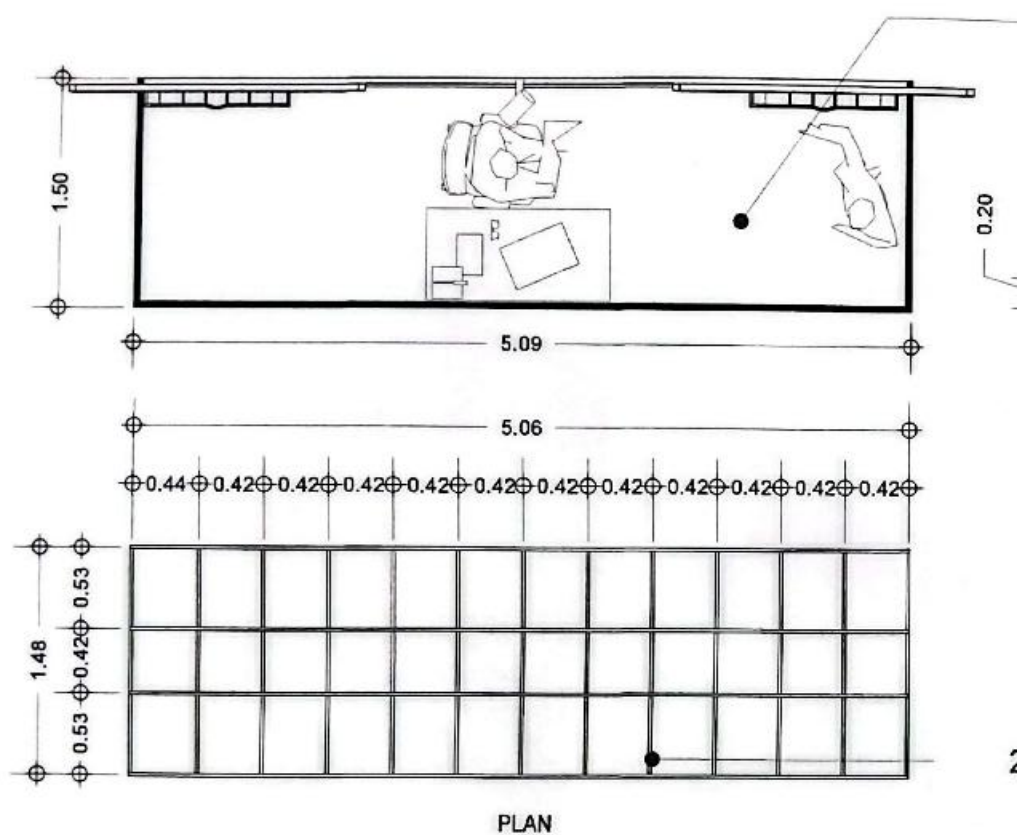


PLYWOOD $\frac{3}{4}$ " THICK

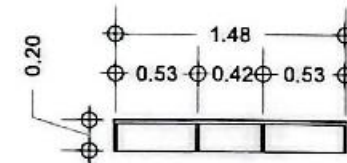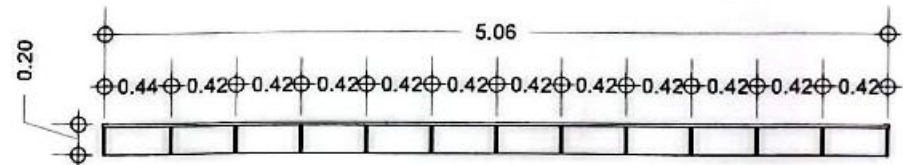


2"x2" GOOD LUMBER

STAGE LAYOUT
SCALE 1 : 35


 SOUTHERN LEYTE STATE UNIVERSITY Office of the President San Roque, Bogo, Southern Leyte	DRAWN BY: JASCHIA WAGAS BSC 1ST YEAR	PREPARED BY: AR. JAMES M. MANGELISTA, UAP PRO. RITZ M. OLIVERIA, RMP ENGR. RYAN A. MACUTO, GREEN (ADP-AA) PROJECT DEVELOPMENT OFFICER II	PROJECT: RENOVATION OF SPEECH LABORATORY LOCATION: SLSU-SOGOD CAMPUS, SAN ROQUE, SOGOD SOUTHERN LEYTE	OWNER: SOUTHERN LEYTE STATE UNIVERSITY ADDRESS: SLSU-SOGOD CAMPUS, SAN ROQUE, SOGOD SOUTHERN LEYTE	APPROVED AS PER PLAN: JUDE A. DARTO, DPA UNIVERSITY PRESIDENT	SHEET CONTENT: AS SHOWN CHECKED: _____ APPROVED: _____ DRAWN: _____ DATE: _____ SCALE: AS SHOWN	SHEET NO.: A-04 PROJ. NO.:
--	--	--	---	--	---	--	--

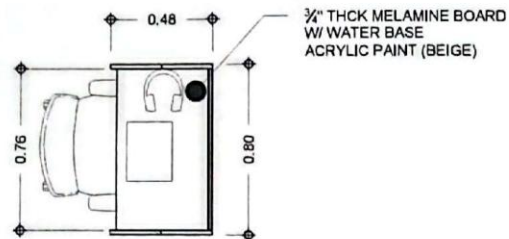

PLAN

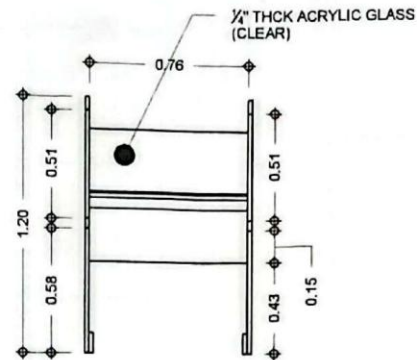


FRONT VIEW

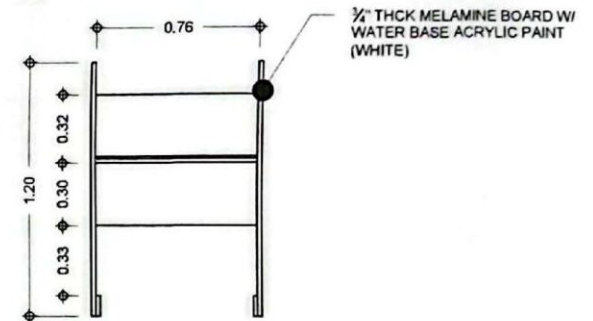


REAR VIEW



PERSPECTIVE

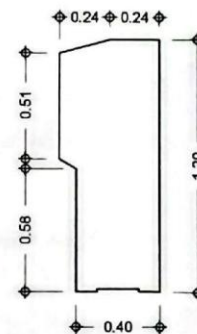


SIDE VIEW

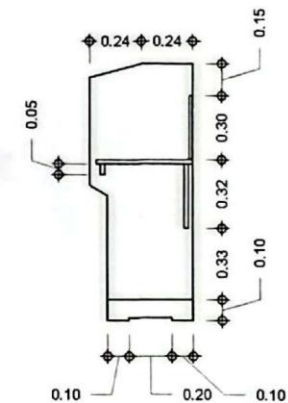

LONGITUDINAL SECTION

CUBICLE LAYOUT
SCALE 1 : 25

 SOUTHERN LEYTE STATE UNIVERSITY Office of the Vice President for Academic Affairs Office of the Vice President for Student Affairs Office of the Vice President for Administration and Finance	DESIGNED BY JASOM WAGAS DESIGNER REVIEWED BY ROMEL WAGAS DESIGNER	PREPARED BY AR. JEAMES M. EVANGELISTA, UAP PROJECT DEVELOPMENT OFFICER I ENGR. KEVIN P. OLIVERON, RMP PROJECT DEVELOPMENT OFFICER I ENGR. RYAN A. MASATO, GREEN ADP+AA PROJECT DEVELOPMENT OFFICER II	PROJECT: RENOVATION OF SPEECH LABORATORY LOCATION: SILBU-SOGOD CAMPUS, SAN ROQUE, SOGOD SOUTHERN LEYTE	OWNER: SOUTHERN LEYTE STATE UNIVERSITY ADDRESS: SILBU-SOGOD CAMPUS, SAN ROQUE, SOGOD SOUTHERN LEYTE	APPROVED AS PER PLAN JUDE A. DUARTE, CPA UNIVERSITY PRESIDENT	SHEET CONTENT AS SHOWN CHECKED: _____ APPROVED: _____ DATE: _____ SCALE: AS SHOWN	SHEET NO. A-05 PRICE NO.
---	---	---	---	--	---	---	---

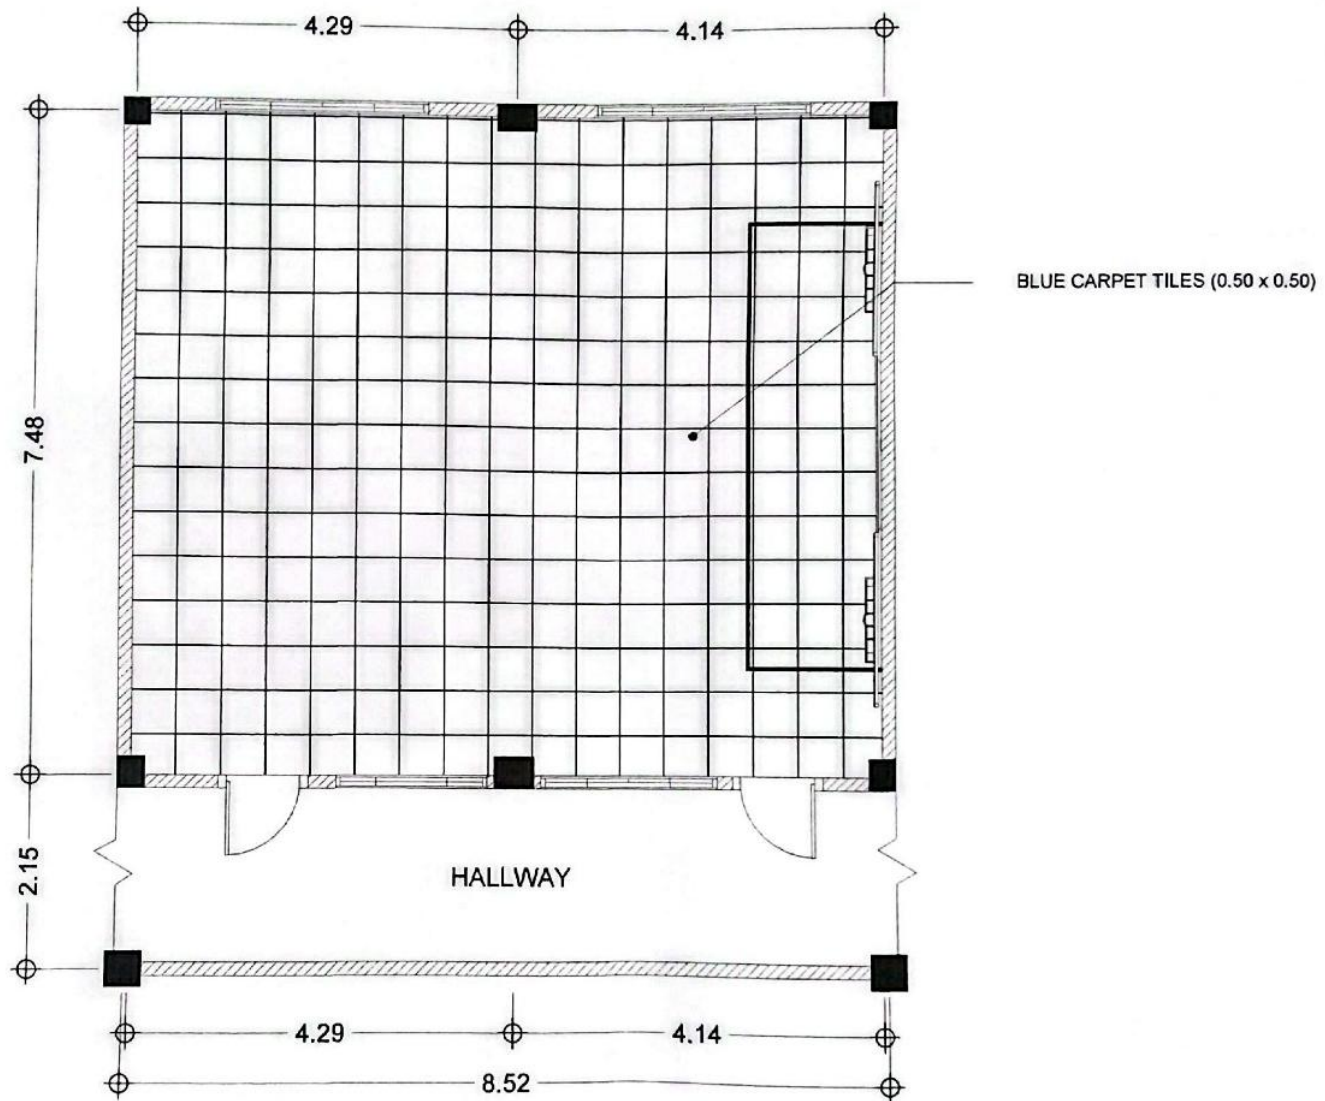

TILE LAYOUT PLAN
SCALE 1 : 60



DRAWN BY
JASON M. WAGAS
BSC-ITEN
ROVEL A. WAGAS
BSC-ITEN

PREPARED BY
AR. JEAMES P. EVANGELISTA, UAP
PROJECT DEVELOPMENT OFFICER II
ENGR. DEWITT P. OLIVERON, RMP
PROJECT DEVELOPMENT OFFICER I
ENGR. RYAN A. MACUTO, GREENE ADP-AA
PROJECT DEVELOPMENT OFFICER III

PROJECT
RENOVATION OF SPEECH
LABORATORY
LOCATION: SLSU-SOGOD CAMPUS, SAN ROQUE, SOGOD SOUTHERN LEYTE


OWNER
SOUTHERN LEYTE STATE UNIVERSITY
ADDRESS: SLSU-SOGOD CAMPUS, SAN ROQUE, SOGOD SOUTHERN LEYTE

APPROVED AS PER PLAN
JUDEL QUARTE, DPA
UNIVERSITY PRESIDENT

SHEET CONTENT
AS SHOWN
CHECKED
APPROVED

SCALE
AS SHOWN
DATE

SHEET NO.
A-06
PROJ. NO.

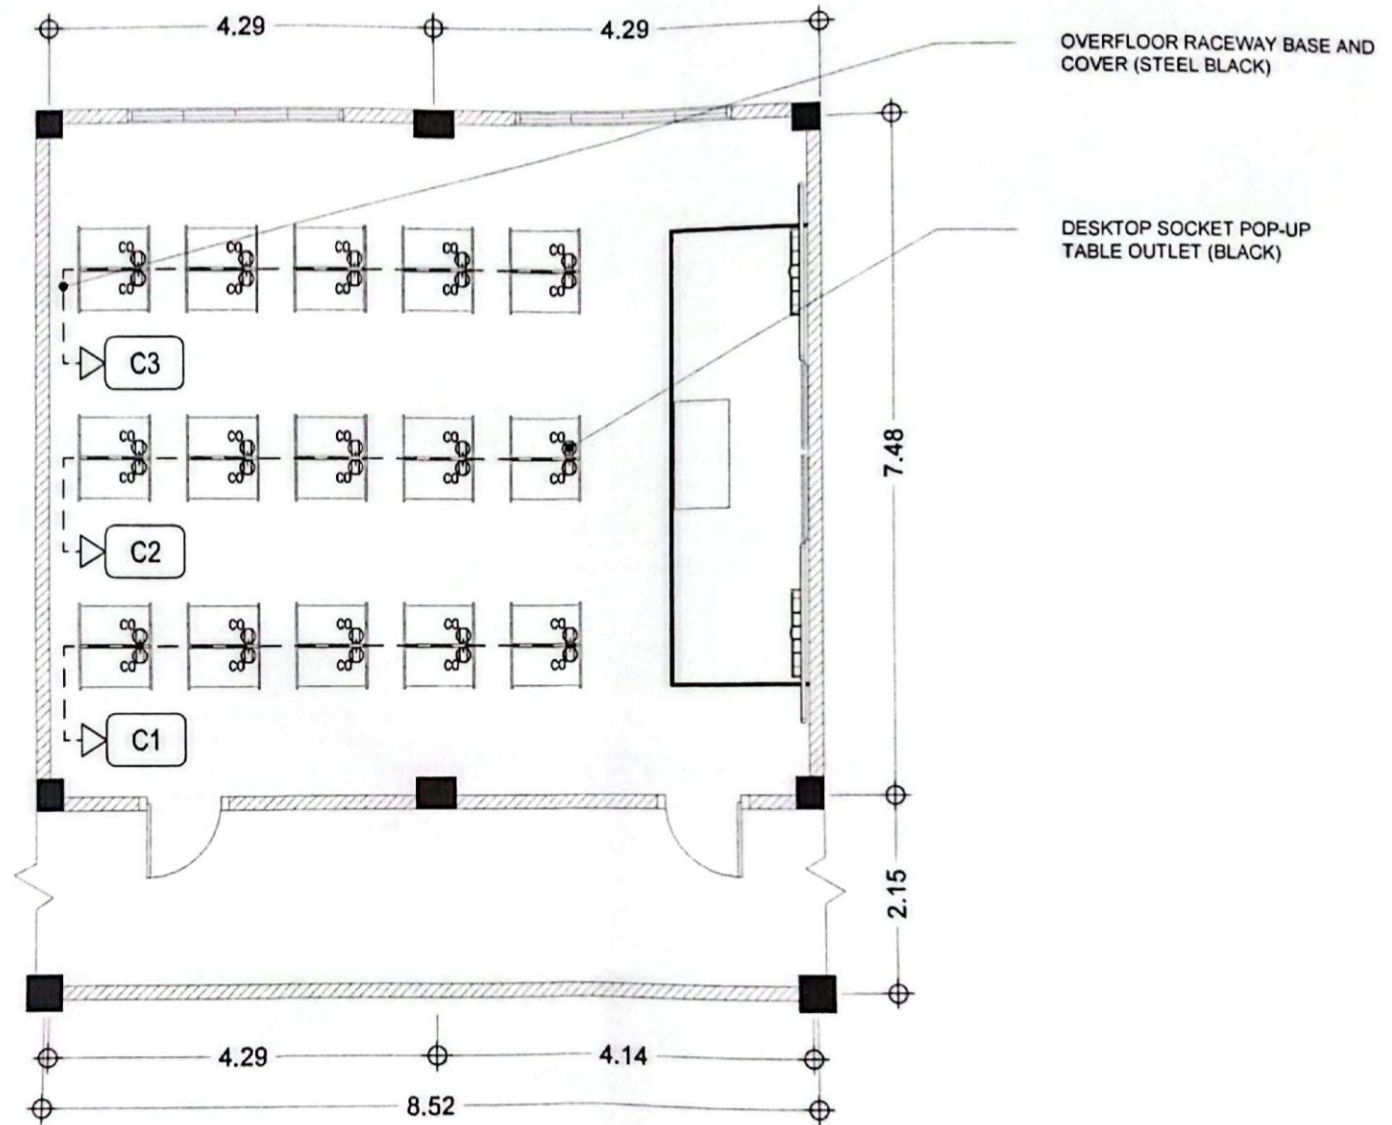

DESIGNED BY
JASON M. VAGAS
DRAWN BY
ROMEL A. VAGAS

PREPARED BY
MR. JAMES M. ANGELISTA, UAP
PROJECT DEVELOPMENT OFFICER I
ENGR. RYAN A. MACULO, GREEN AOP-IA
PROJECT DEVELOPMENT OFFICER II

PROJECT
RENOVATION OF SPEECH
LABORATORY
LOCATION: SLSU-RODOD CAMPUS, SAN ROGUE, RODOD SOUTHERN LEYTE

OWNER
SOUTHERN LEYTE STATE UNIVERSITY
ADDRESS: SLSU-RODOD CAMPUS, SAN ROGUE, RODOD SOUTHERN LEYTE

APPROVED AS PER PLAN
JUDE A. QUARTE, DPA
UNIVERSITY PRESIDENT

SHEET CONTENT
AS SHOWN
CHECKED
APPROVED
DRAWN
DATE
SCALE
AS SHOWN
SHEET NO.
E-01
PROJ. NO.

SCHEDULE OF LOADS (PP)

CKT. NO.	DESCRIPTION	POWER(VA)	VOLTS	LOAD(AMPERS)			OCPD	CONDUCTOR	CONDUIT
				ØAB	ØBC	ØCA			
1	C.O. (10)	2500	220	11.36			20 AT, 20 AF, 2P	2 - 5.5 mm² sq. THHN + 1- 2.0 TW(G)	20 mm dia. PVC
2	C.O. (10)	2500	220		11.36		20 AT, 20 AF, 2P	2 - 5.5 mm² sq. THHN + 1- 2.0 TW(G)	20 mm dia. PVC
3	C.O. (10)	2500	220			11.36	20 AT, 20 AF, 2P	2 - 5.5 mm² sq. THHN + 1- 2.0 TW(G)	20 mm dia. PVC
TOTAL				11.36 A	11.36 A	11.36 A			

COMPUTATION OF SERVICE EQUIPMENT

TOTAL WIRE AMPACITY = (TOTAL CURRENT × 80% DEMAND FACTOR) + (25% OF LARGEST MOTOR)

TOTAL WIRE AMPACITY = (11.36 × 0.8) + (0)

TOTAL WIRE AMPACITY = 9.088 Amperes

CIRCUIT BREAKER	USE 1 - 20 AT, 20WAF, 3P BOLT-ON TYPE CB, 220 - 240V, 18 kAIC
CONDUCTOR	USE 3 - 8 mm² THHN + 1 - 3.5 mm² TW (G)
CONDUIT	USE 20 mm dia. PVC

SCHEDULE OF LOADS
SCALE 1 : 50



DESIGNED BY
JASON M. VAGAS
ELECTRICAL ENGINEER
CHECKED BY
ROMEL A. VAGAS
ELECTRICAL ENGINEER

PREPARED BY
AR. JEAMES P. ANGELISTA, UAP
PROJECT DEVELOPMENT OFFICER II
ENGR. KEVIN P. BUTERON, RMP
PROJECT DEVELOPMENT OFFICER I
ENGR. RYAN A. MAGUTO, GREENH ADP-AA
PROJECT DEVELOPMENT OFFICER III

PROJECT
RENOVATION OF SPEECH
LABORATORY
LOCATION: SLSU-SOGOD CAMPUS, SAN ROQUE, SOGOD SOUTHERN LEYTE

OWNER
SOUTHERN LEYTE STATE UNIVERSITY
ADDRESS: SLSU-SOGOD CAMPUS, SAN ROQUE, SOGOD SOUTHERN LEYTE

APPROVED AS PER PLAN
JUDGE A. QUARTE, DPA
UNIVERSITY PRESIDENT

SHEET CONTENT
AS SHOWN
CHECKED
APPROVED
DATE
SCALE
AS SHOWN
SHEET NO.
E-02
PROJECT NO.